





LEGEND	
HALL	
VET AREA	
MARKET'S SHOPS	
DOOR	
WINDOWS	

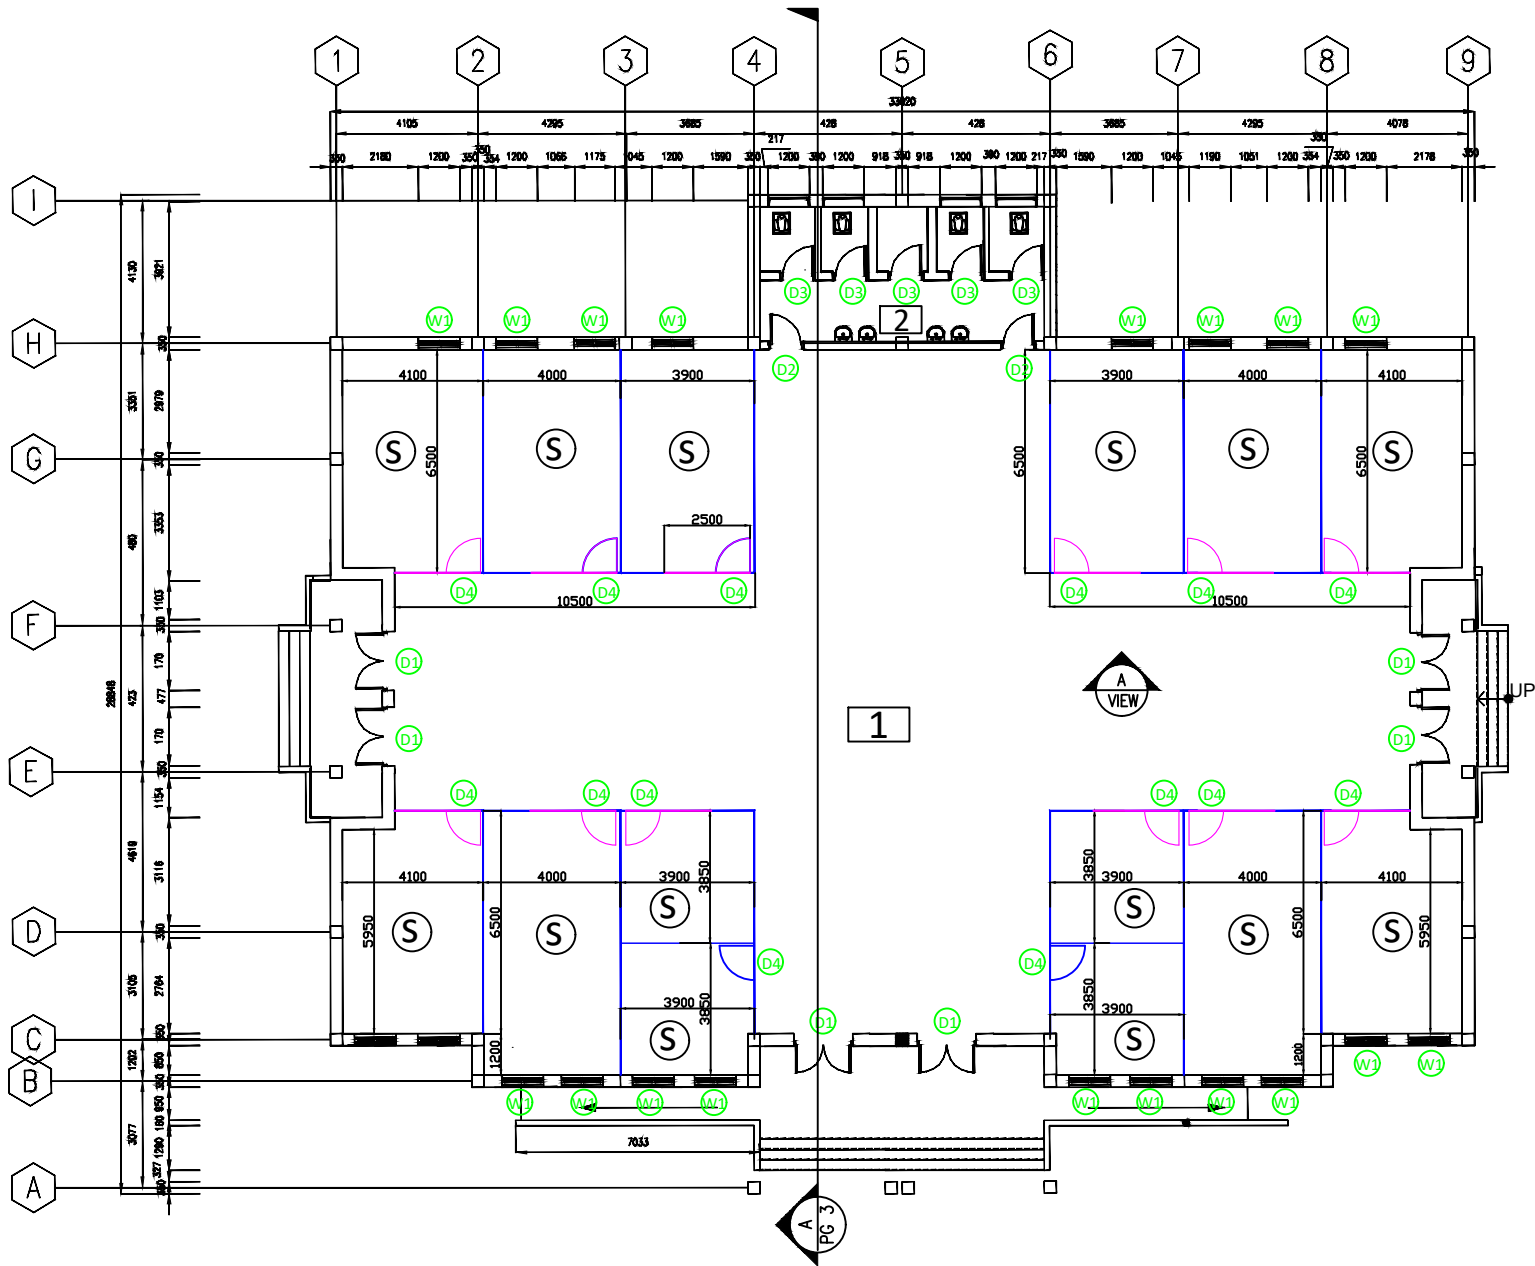


1 FEROZKOH MARKET SHOP'S CELL PLAN
FR.M SCALE:1:100



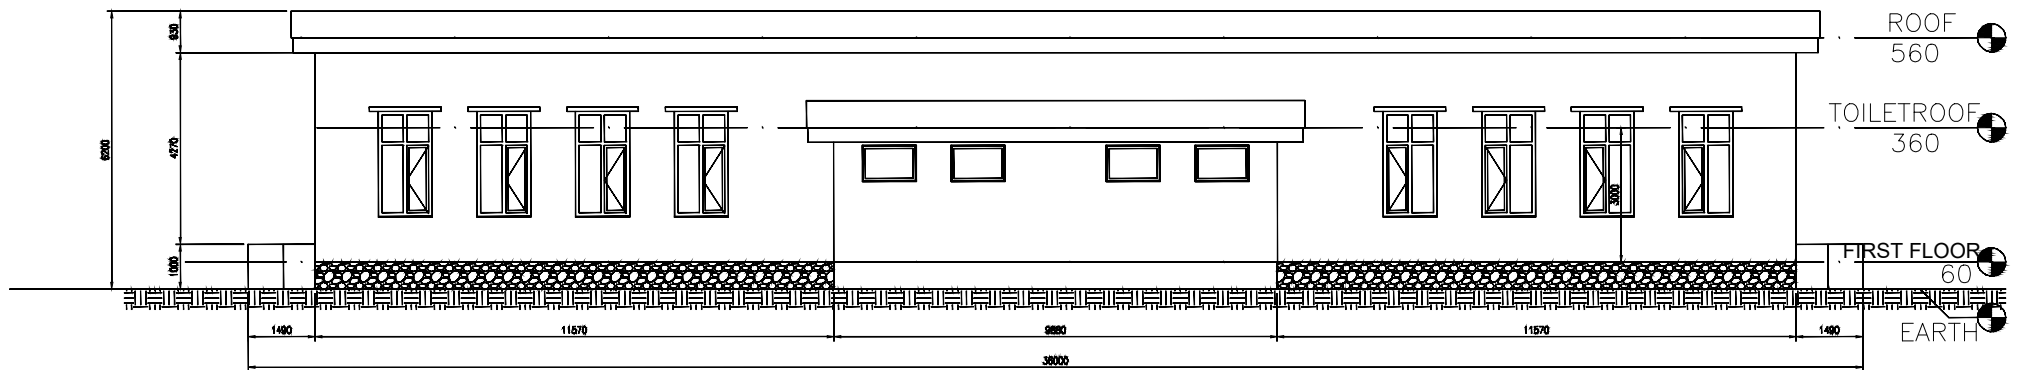Prepared By:	Mashal Ayaz	Checked By:	Dawood Shafaq	 ISLAMIC RELIEF WORLDWIDE AFGHANISTAN  ABADEI #2, UNDP PROJECT	PROJECT NAME	FEROZKOH CITY, WOMEN-MARKET REHABILITATION
Controlled By:	M Rafi Sangi	Approved By:	Country Office PM		PROJECT ID	PDF-GHR/FRK 24
Verified By:		Verified By:	Country Directore		SHEET NO	1

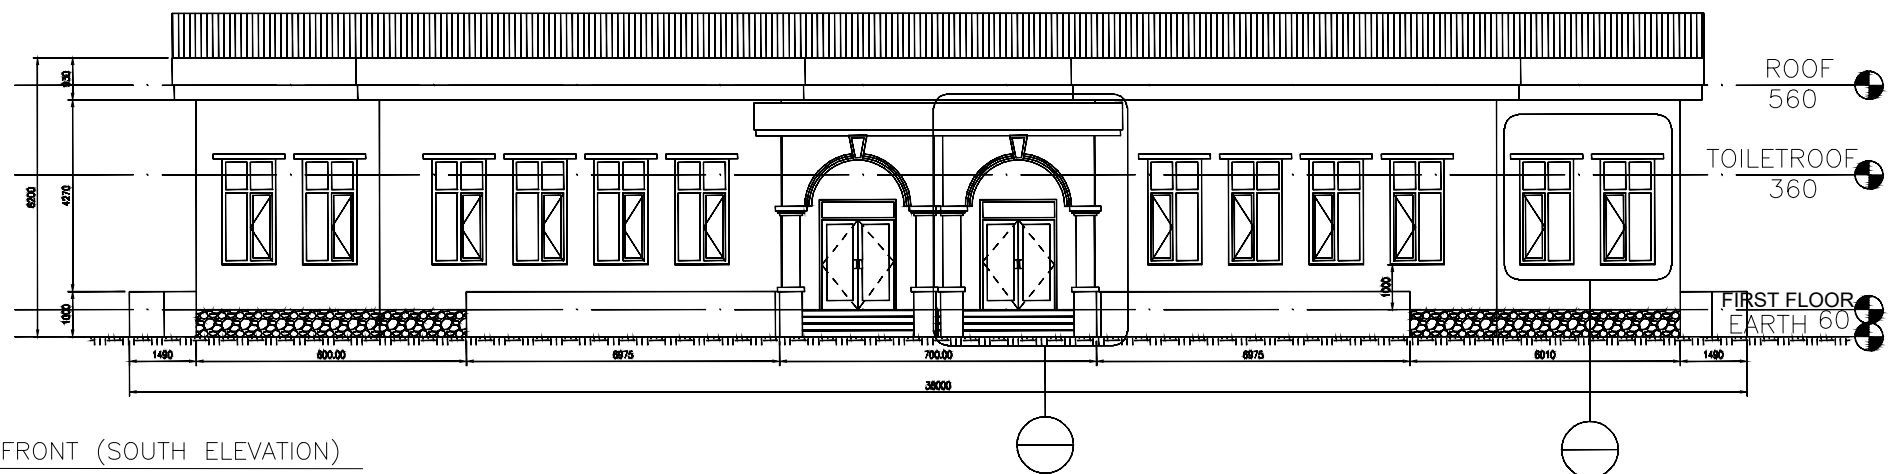


1 BACK (NORTH ELEVATION)
FR.M SCALE:NTS



2 FRONT (SOUTH ELEVATION)
FR.M SCALE:NTS


Prepared By:	Mashal Ayaz	Checked By:	Dawood Shafaq	 ISLAMIC RELIEF WORLDWIDE AFGHANISTAN ABADEI #2, UNDP PROJECT		PROJECT NAME	FEROZKOH CITY, WOMEN-MARKET REHABILITATION
Controlled By:	M Rafi Sangi	Approved By:	Country Office PM			PROJECT ID	PDF-GHR/FRK 24
Verified By:		Verified By:	Country Directore			SHEET NO	3

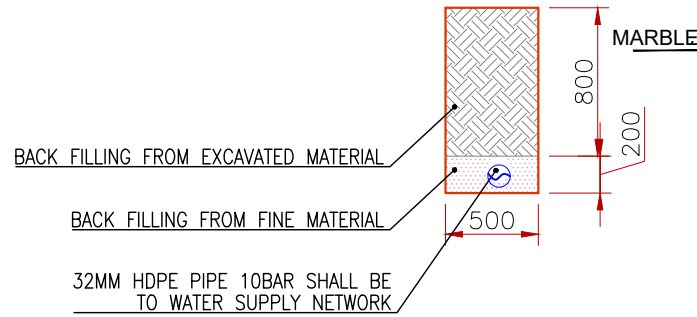

1 PILE LINE EXCAVATION SECTION
FR.M SCALE:NTS


NEW DOUBLE GLASSES
WITH ANTI SHAKING LAYER.

PVC 7000 FRAME JUST
SHALL BE REPAIRED

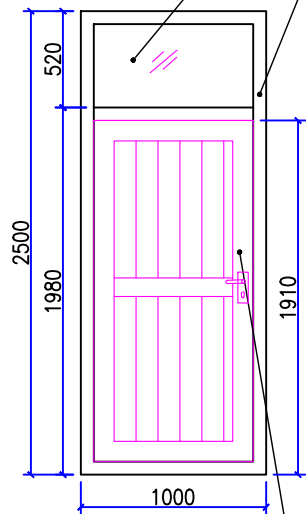


NEW PVC 7000 DOOR OPENING
WITH ALL ACCESSORIES

1 DOOR D2 AND D3
FR.M SCALE:NTS

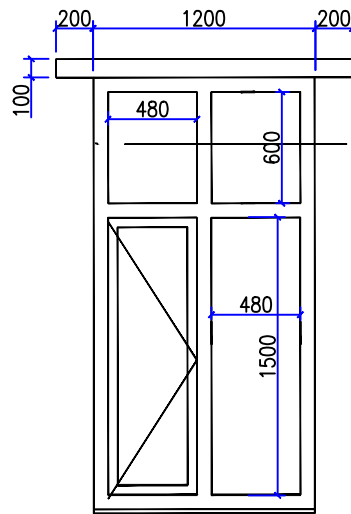


TOILET ROOF
360

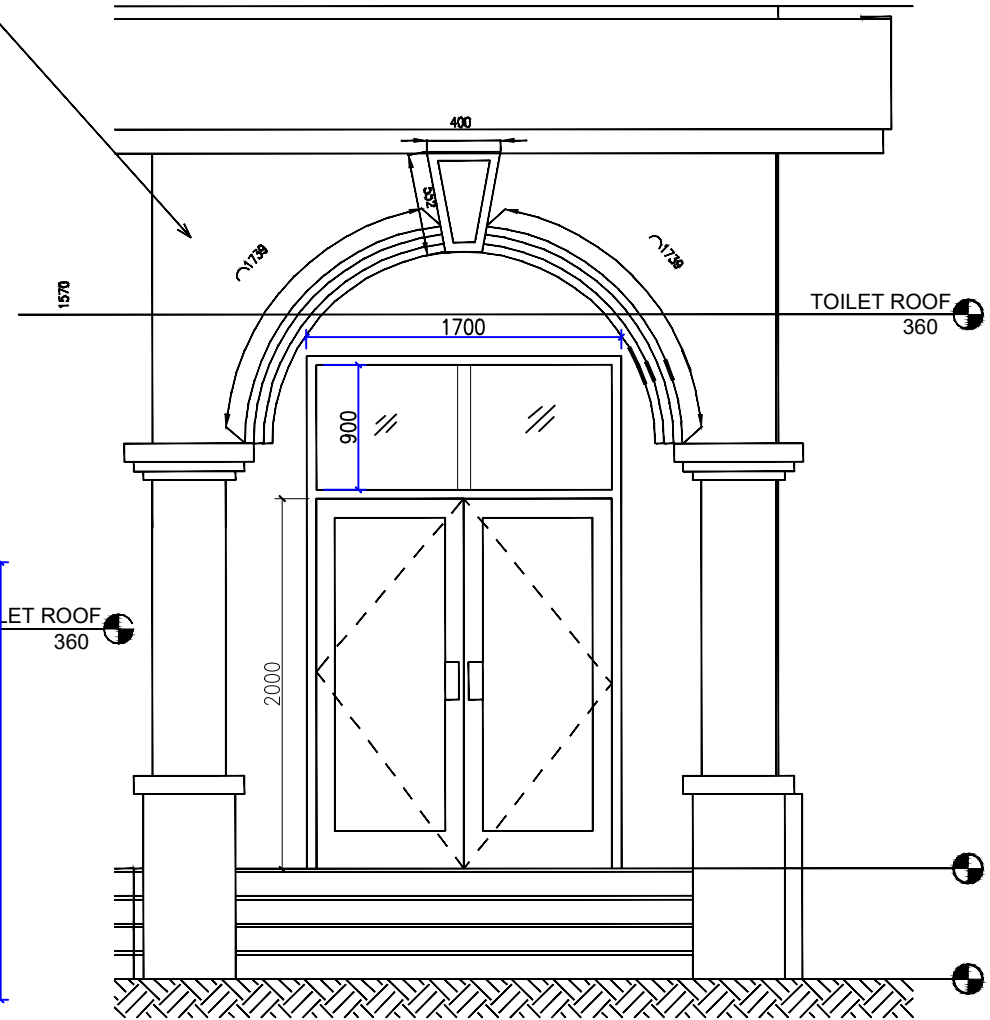

1 D1 & W1 DIMENSION
FR.M SCALE:NTS

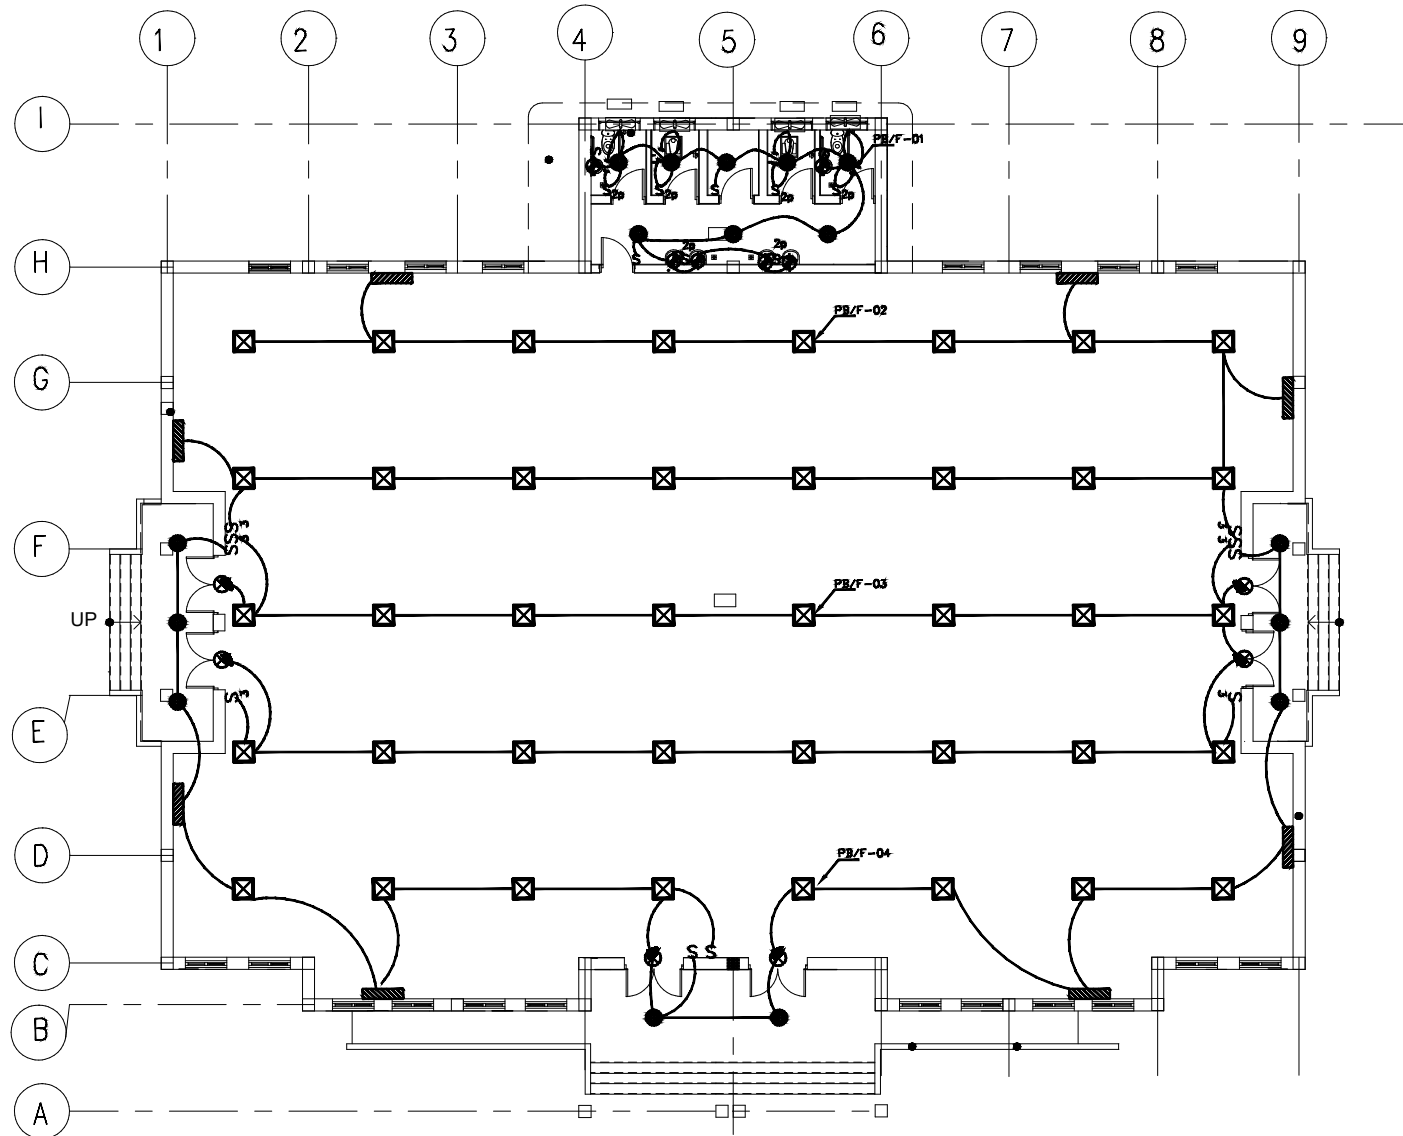


Prepared By:	Mashal Ayaz	Checked By:	Dawood Shafaq	ISLAMIC RELIEF WORLDWIDE AFGHANISTAN	PROJECT NAME	FEROZKOH CITY, WOMEN-MARKET REHABILITATION
Controlled By:	M Rafi Sangi	Approved By:	Country Office PM	ABADEI #2, UNDP PROJECT	PROJECT ID	PDF-GHR/FRK 24
Verified By:		Verified By:	Country Directore		SHEET NO	4





1 FEROZKOH MARKET LIGHTING PLAN
FR.M SCALE:NTS

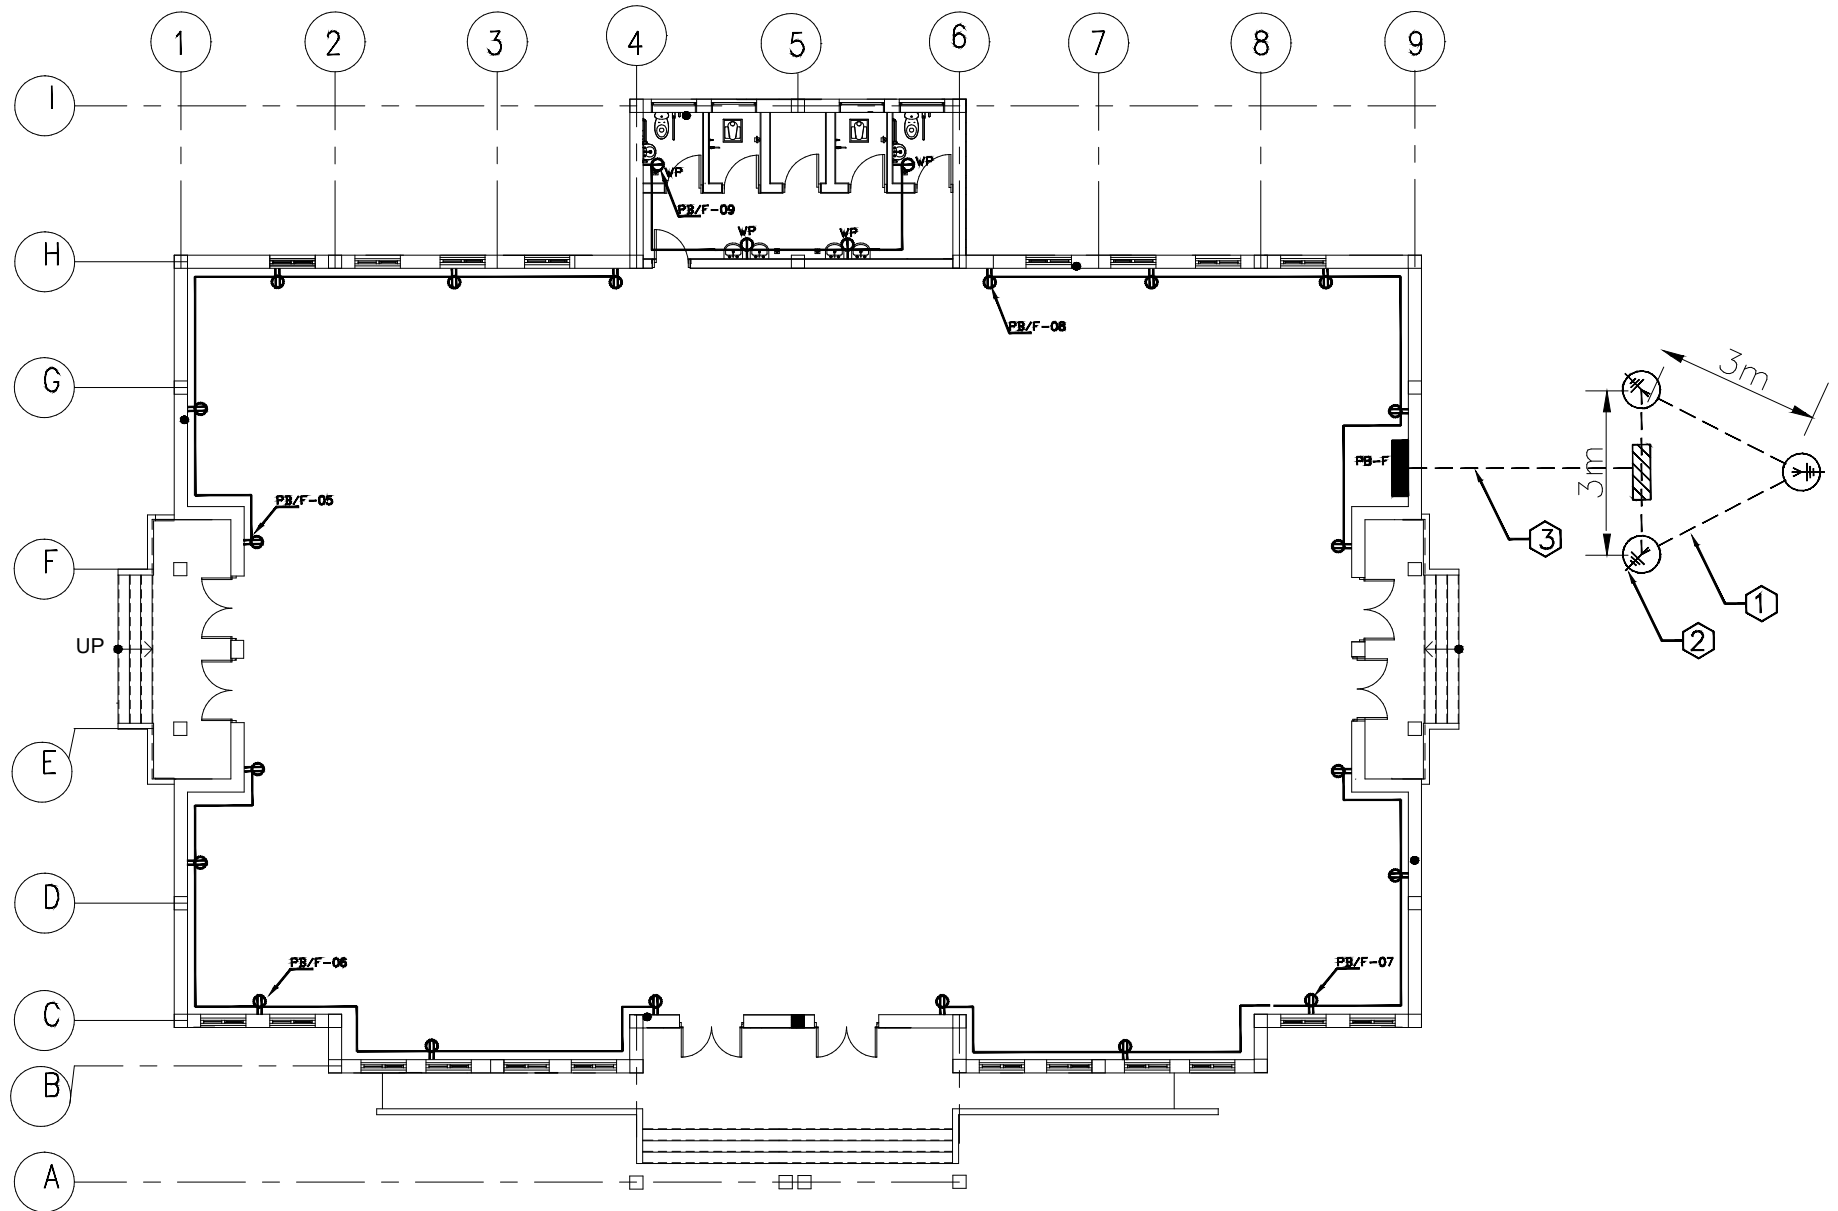Prepared By:	Mashal Ayaz	Checked By:	Dawood Shafaq	 ISLAMIC RELIEF WORLDWIDE AFGHANISTAN  ABADEI #2, UNDP PROJECT	PROJECT NAME	FEROZKOH CITY, WOMEN-MARKET REHABILITATION
Controlled By:	M Rafi Sangi	Approved By:	Country Office PM		PROJECT ID	PDF-GHR/FRK 24
Verified By:		Verified By:	Country Directore		SHEET NO	5



1 POWER AND GRINDING PLAN
FR.M SCALE:NTS

Prepared By:	Mashal Ayaz	Checked By:	Dawood Shafaq	 ISLAMIC RELIEF WORLDWIDE AFGHANISTAN ABADEI #2, UNDP PROJECT		PROJECT NAME	FEROZKOH CITY, WOMEN-MARKET REHABILITATION
Controlled By:	M Rafi Sangi	Approved By:	Country Office PM			PROJECT ID	PDF-GHR/FRK 24
Verified By:		Verified By:	Country Directore			SHEET NO	6