



Islamic Relief Worldwide

IR-W-AF

Central Region

Bamiyan Provincial


Office

NICE Project, IR-UK


Sub Health Center


Sayeed baba, Saighan District, Bamiyan Province,
Afghanistan

Submission Date: 2024

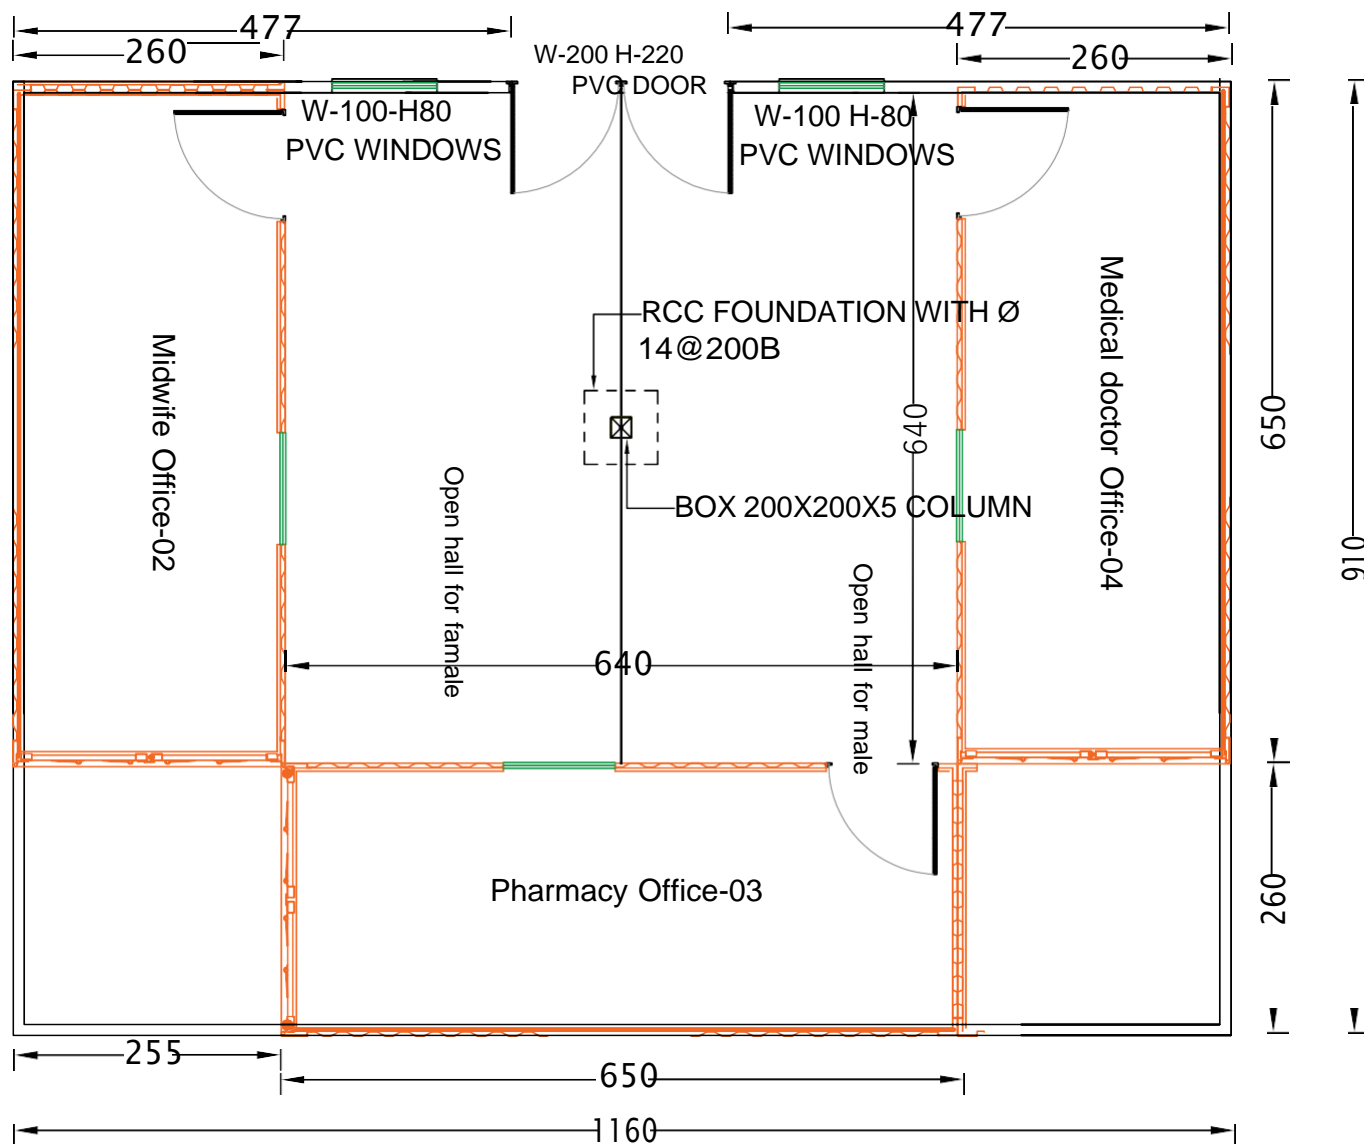

HeLP IR-Canada-Health Service Point

Survey: By	Eng.Mohammad.Mehdi Azimi	Project	NICE	Islamic Relief Worldwide		
Drawing: By	Eng.Mohammad.Moaine Rahimi	Section	Health	IR-AF		
Design : By	Eng.Mohammad.Moaine Rahimi	Date	2024	Unit	cm	
Checkd: By		Province	Bamiyan		NO	
Approved: B		District	Saighan		Sheet No	
		Village	Sayeed baba		0	

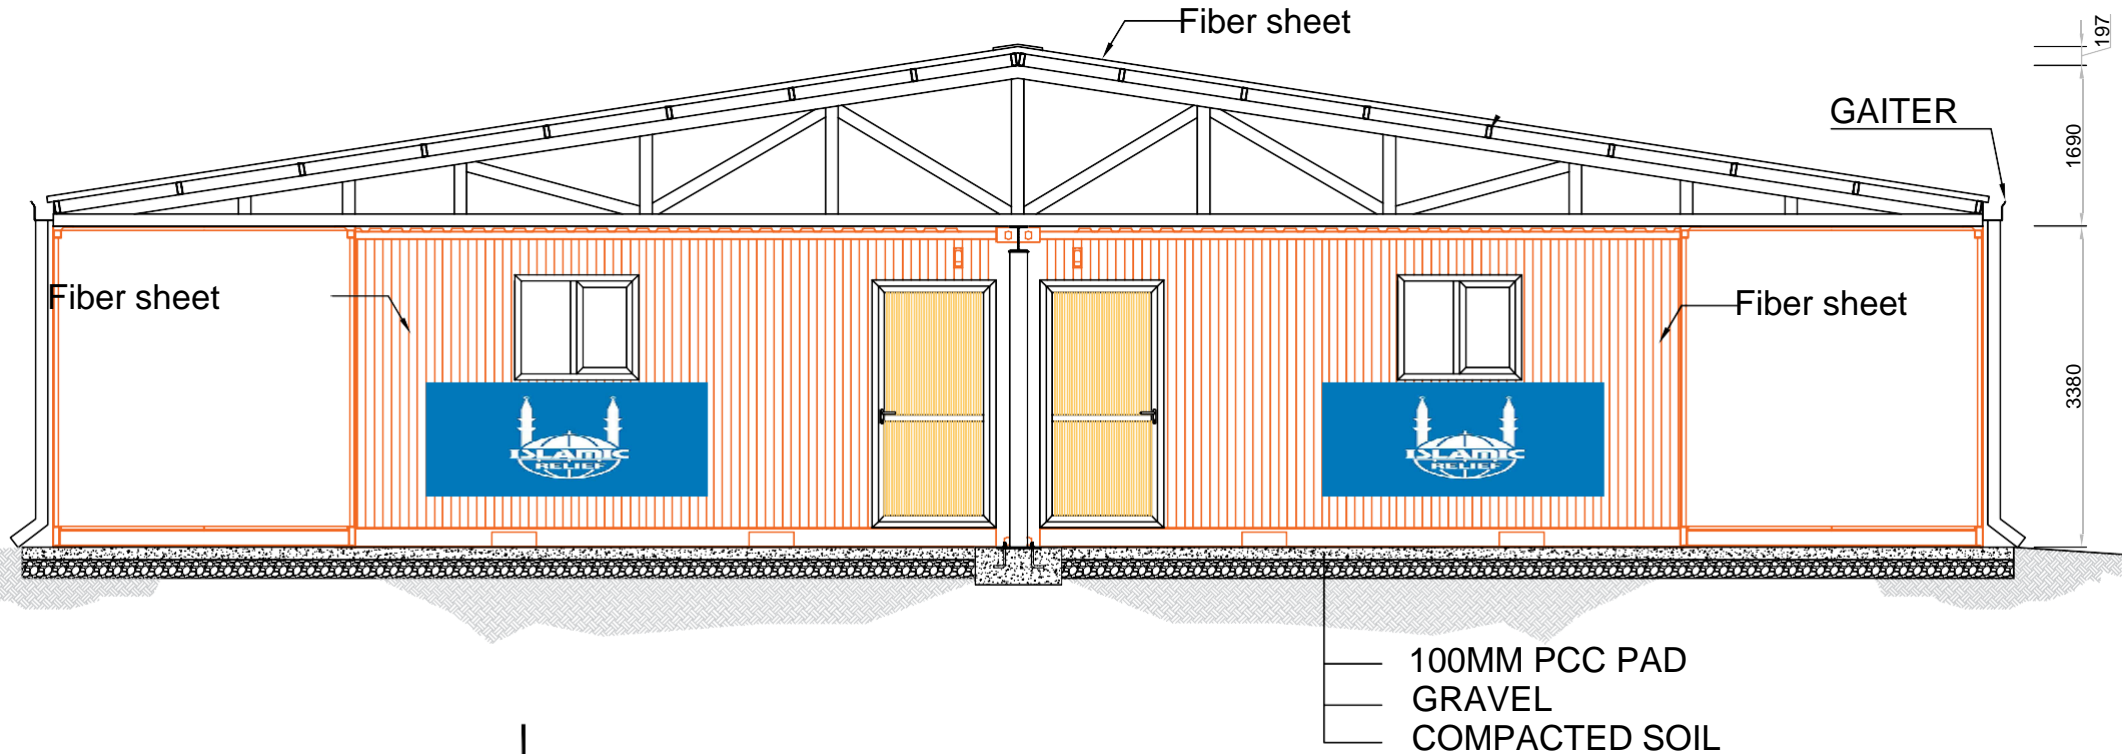


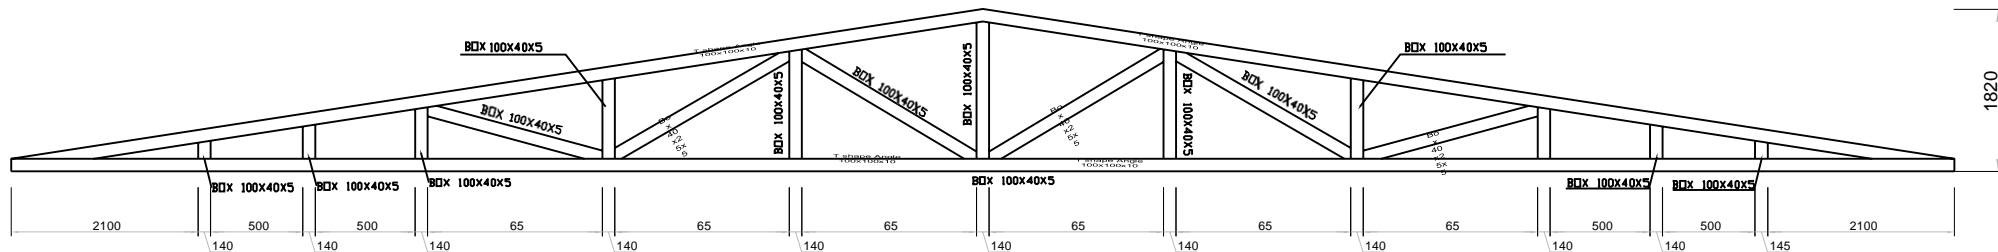
2 SECTION

A-100

SCALE :N.T.S

HeLP IR-Canada-Health Service Point

Survey: By	Eng.Mohammad.Mehdi Azimi	Project	NICE	Islamic Relief Worldwide		
Drawing: By	Eng.Mohammad.Moaine Rahimi	Section	Health	IR-AF		
Design : By	Eng.Mohammad.Moaine Rahimi	Date	2024	Unit	cm	
Checkd: By		Province	Bamiyan	Scale	NO	
Approved: B		District	Saighan	Sheet No	0	
		Village	Sayeed baba			




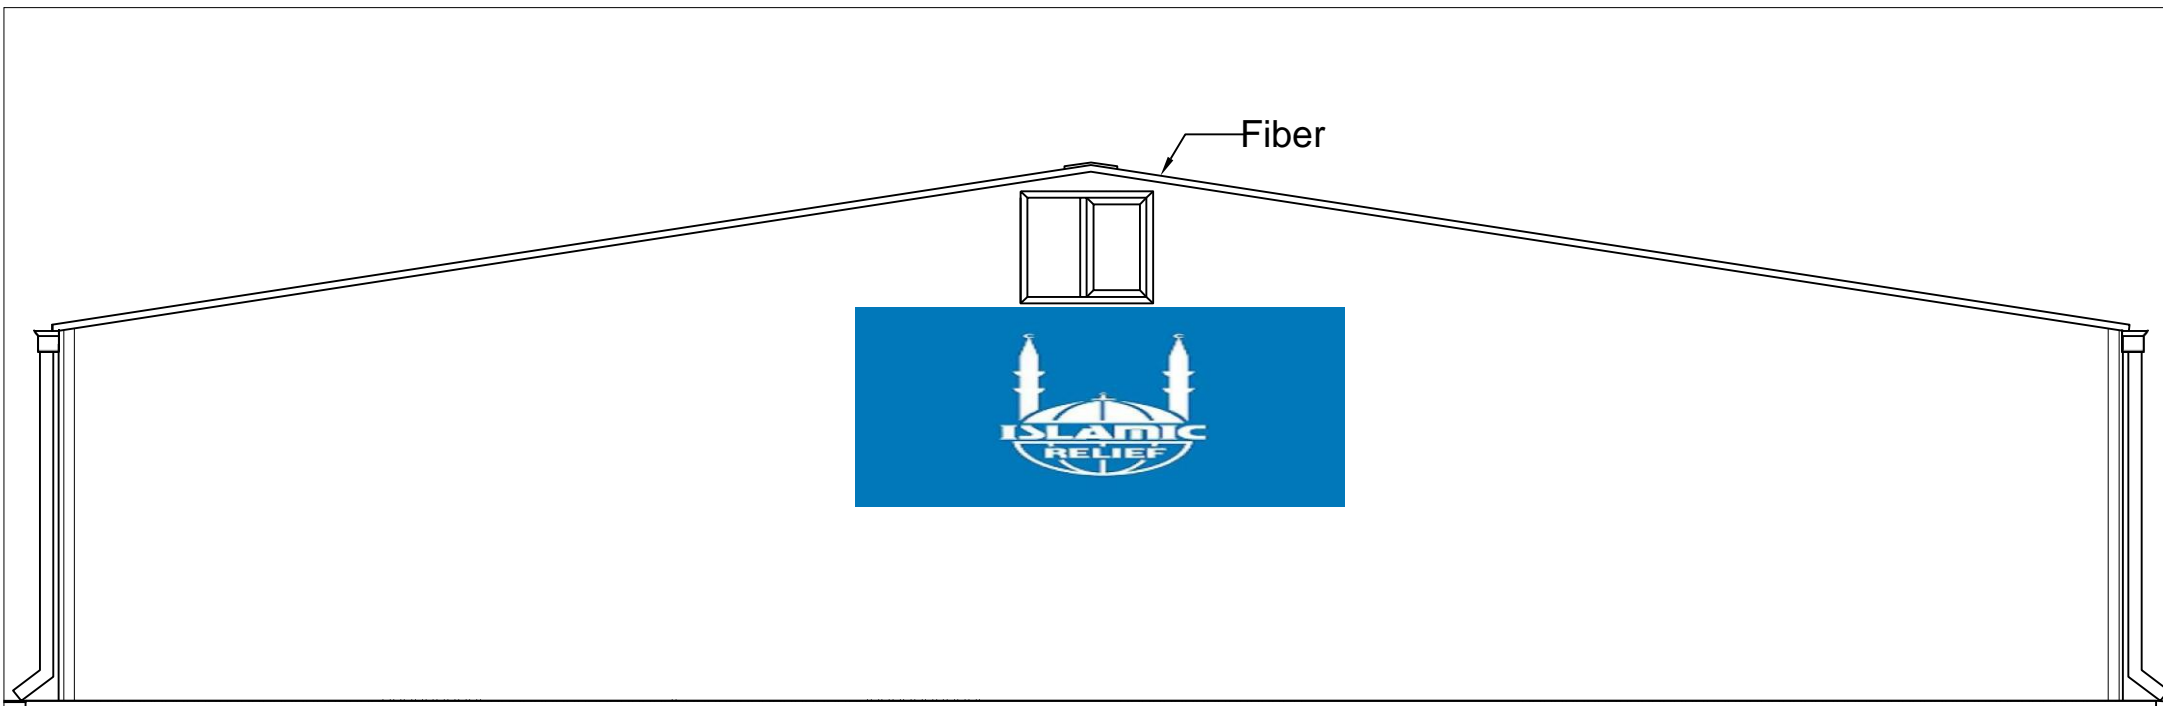
2 DETAIL

A-101

SCALE :N.T.S

HeLP IR-Canada-Health Service Point

Survey: By	Eng.Mohammad.Mehdi Azimi	Project	NICE	Islamic Relief Worldwide		
Drawing: By	Eng.Mohammad.Moaine Rahimi	Section	Health	IR-AF		
Design : By	Eng.Mohammad.Moaine Rahimi	Date	2024	Unit	cm	
Checkd: By		Province	Bamiyan	Scale	NO	
Approved: B		District	Saighan	Sheet No	0	
		Village	Sayeed baba			




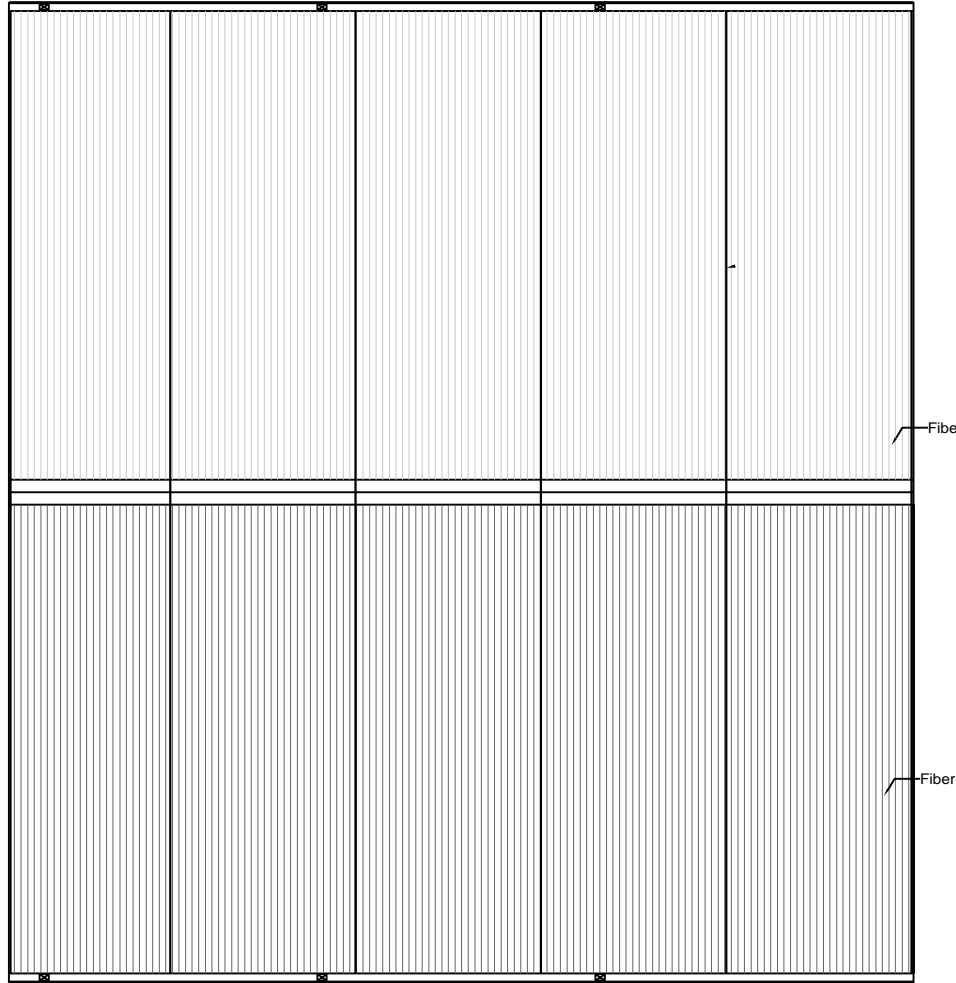
1 ELEVATION

A-100

SCALE :N.T.S


HeLP IR-Canada-Health Service Point

Survey: By	Eng.Mohammad.Mehdi Azimi	Project	NICE	Islamic Relief Worldwide		
Drawing: By	Eng.Mohammad.Moaine Rahimi	Section	Health	IR-AF		
Design : By	Eng.Mohammad.Moaine Rahimi	Date	2024	Unit	cm	
Checkd: By		Province	Bamiyan	Scale	NO	
Approved: By		District	Saighan			
		Village	Sayeed baba	Sheet No	0	



1 ROOF PLAN
A-100 SCALE :N.T.S

HeLP IR-Canada-Health Service Point

Survey: By	Eng.Mohammad.Mehdi Azimi	Project	NICE	Islamic Relief Worldwide		
Drawing: By	Eng.Mohammad.Moaine Rahimi	Section	Health	IR-AF		
Design : By	Eng.Mohammad.Moaine Rahimi	Date	2024	Unit	cm	
Checkd: By v		Province	Bamiyan	Scale	NO	
Approved: B		District	Saighan			
		Village	Sayeed baba	Sheet No	0	



Islamic Relief Worldwide-Afghanistan

Bamiyan Provincial Office

Province: Bamiyan

District: Saighan

Village: Sayeed baba

Date: 06.05.2024

NICE Project

BOQ

S/NO شماره	توضیحات Descriptions	Unit واحد	Quantity مقدار	Estimated Cost/Unit (Afs.) تخمین فی واحد	Total Cost (Afs.) قیمت مجموعی	Remarks ملاحظات
Health service point.						
1	Conex Container 20 feet or (6*2.45 meter) Conex Lin good condition (Italian made is preferable), resistant to heat and cold. attached bathroom (shower, flash tank, sink, toilet seat) in two of them, exhaust fan 1 per container and lighting, - Conex condition should be 70% -100%new, propel 5 mm. painting with high quality, blow, and white color and IRW Logo, Transportation and installation to Saighan district, Sayeed baba Village.	No	3			
2	Solar panels - Solar Panel 250-watt Sheel Company, - 30 meter wire, 6 mm, Maghan company	No	3			
3	Truss - Truss work as per attached design with all materials supply and installation, - T shape angle 100x100x10 supply and installation - Box 100x40x5 with supply and installation. - Box 40x25x5 with supply and installation point, roof, front, behind with all materials supply and installation, and center column 200x200x5 box with RCC foundation. Fiber (made in Iran) covering with installation charges 120 to 200km/h (75 to 125 miles/h) 20+ years.	LM	1			
4	PVC door high quality door 220x200 as per design PVC/Aluminum alloy (dual pane options).	No	1			
5	Windows - PVC high quality windows 100x800 as per design PVC/Aluminum alloy (dual pane options).	No	3			
6	Carpet (mocket) 6*3m, made in Iran.	No	3			
7	Air Cooler - Air cooler (local made) good condition, 18-gauge metal sheet, - Installation to conex container.	No	3			
8	Concrete foundation 10*12 M2, thickness 10 cm, - 12 concrete beams height 50cm, wide 50cm and length 50cm - (M:250) concrete 1:1.5:2	LM	1			
9	visibility Notice board (Curley), wide 50cm, length 15M, metal sheet gauge 20mm, with high quality painting and IRW logo.	LM	1			
10	Septic Well Construction of 4 meter deep and 1x1 squire meter wide septic well and sewerage pipe system up to each washroom and installation of concrete rings.	No	1			

11	Water tank (plastic type) 3000 litter capacity, with Installation including fitting pipes up to two-unit washroom Cover for water tank to protect from Heat and Coldness.	No			
Sub-Total Cost (Afs)					
Grand Total Cost (Afs.) لټولنه مجموعې ته د غټالي					

Prepared by:

Checked by:

Verified by:

APPROVED BY: