


# Site plan for Shash Borja water supply project

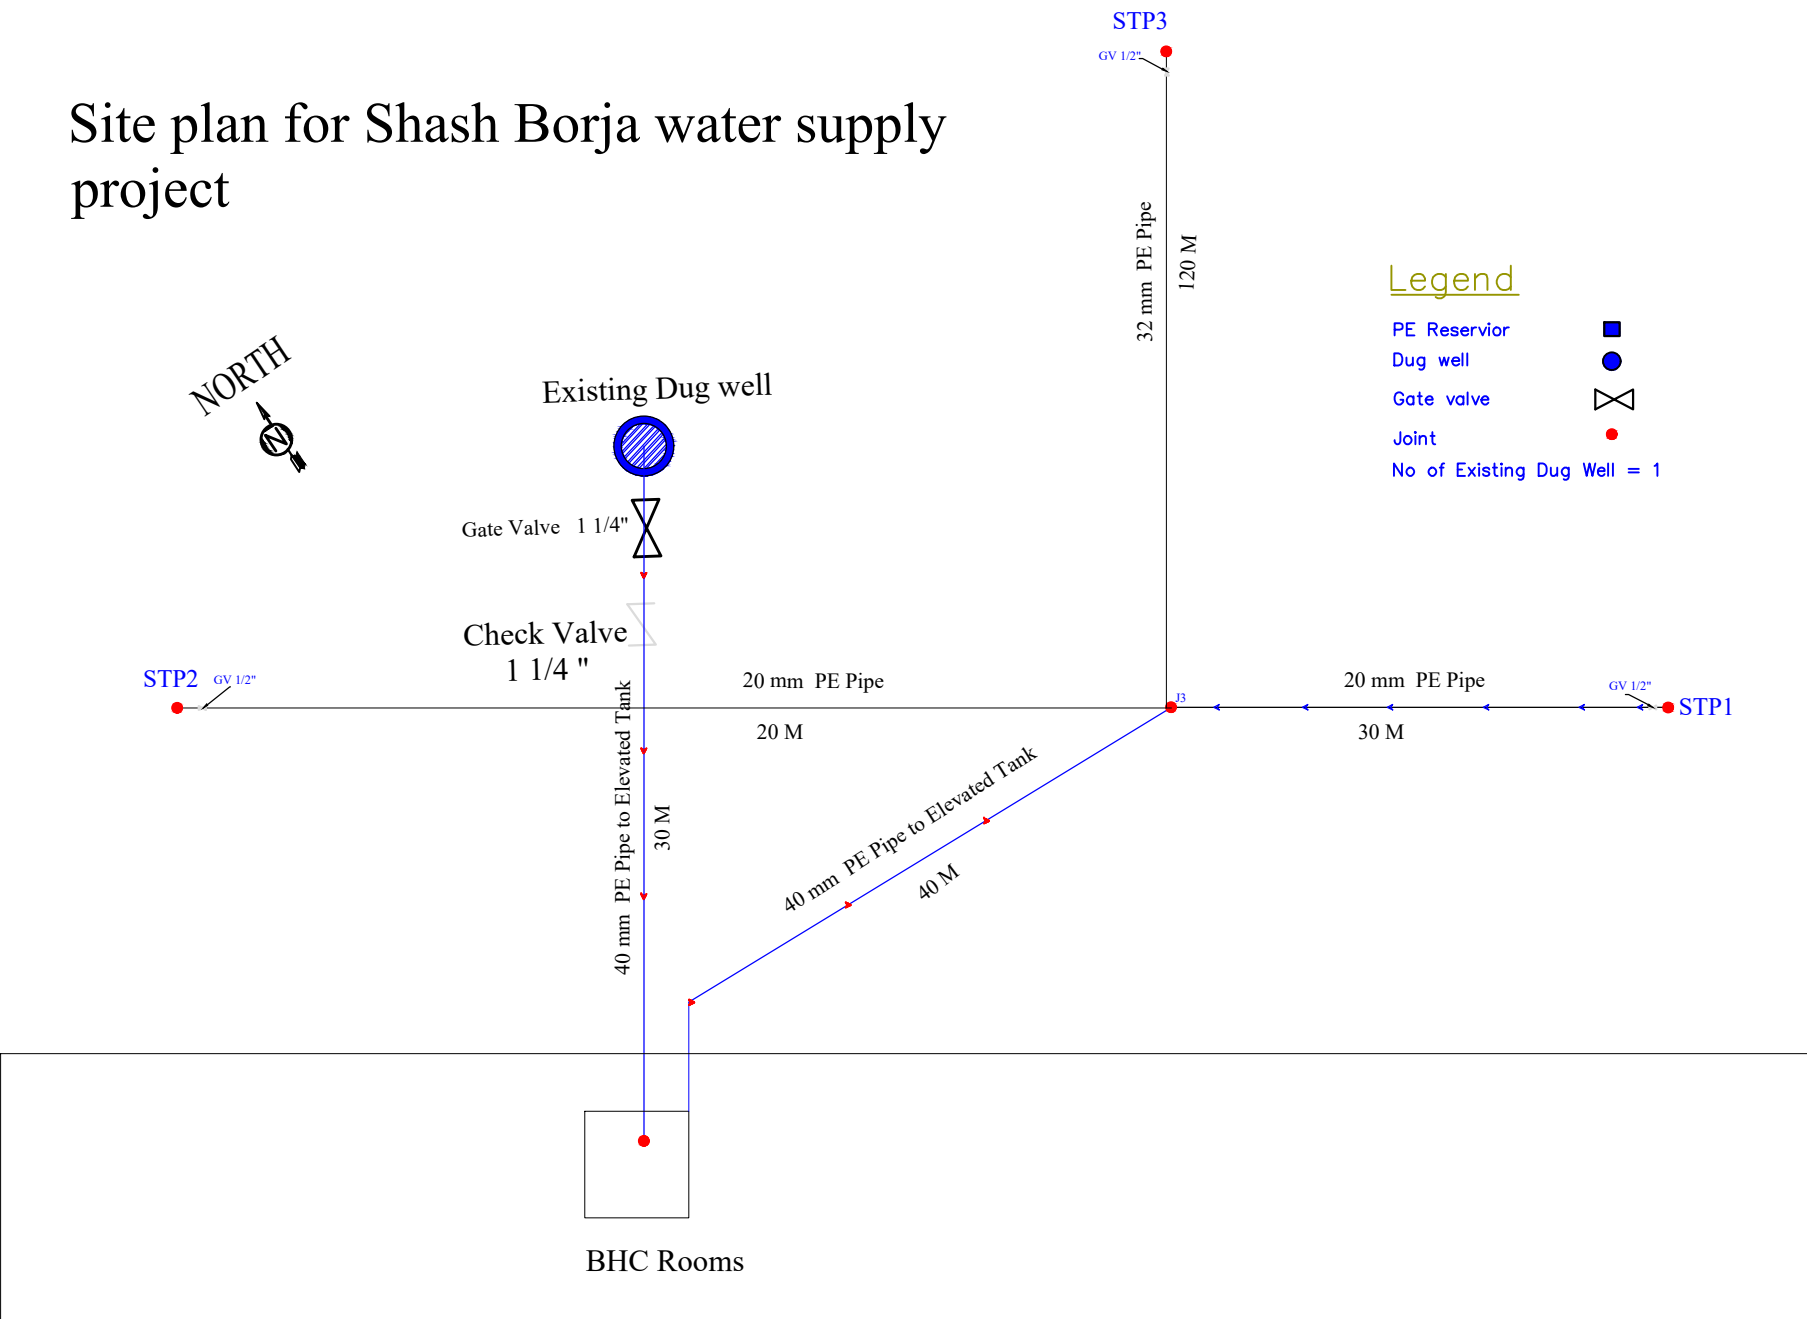

	Afghanistan	Title: Site Plan		Drawn by: Obaidullah Muneeb	Drawing number: 1 / 1
	Khas Uruzgan			Checked by: Conner Wingerter	
	ECHO			Date: 27-05-2024	Scale (A4): 1:100