




PROJECT NAME : RENOVATION OF (Ghazi Mohamad Jan Khan High school)

PROJECT EMPLOYER : UNITED NATIONS CHILDREN'S FUND

PREPARE BY : CONSTRUCTION SECTION



PROJECT EMPLOYER
UNITED NATIONS CHILDREN'S FUND
construction section
Renovation of Ghazi Mohamad Jan Khan High school
All dimension are in cm

TITLE : TABLE OF CONTENTS

MOHAMMAD HAMAYOON "KARIMI"

DRAWING BY

CHECKED BY

APPROVED BY

UNICEF

C.S

SHEET No

SCALE

DATE

A-1/12

AS SHOWN

APRIL 2024

S.N	TABLE OF CONTENTS
A- 1/12	TABLE OF CONTENTS
A- 2/12	MATERIALS SYBOLS
A- 3/12	GOOGLE MAP "ROAD MAP"
A- 4/12	GOOGLE SCHOOL IMAGE
A- 5/12	GENERAL SITE PLAN
A- 6/12	SCHOOL SITE PLAN
A- 7/12	SCHOOL FIRST FLOOR PLAN
A- 8/12	SCHOOL SECOND FLOOR PLAN
A- 9/12	SCHOOL THIRD FLOOR PLAN
A- 10/12	EXISTING TRUSS FRAME AND DETAILS
A- 11/12	SCHOOL TYPICAL ELECTRICAL SYSTEM
A- 12/12	LATRINE PALN

UNICEF

SHEET No

A-2/12

SCALE

AS SHOWN

DATE

APRIL . 2024

TITLE : MATERIALS SYMBOLS

DRAWING BY

MOHAMMAD HAMAYOON "KARIMI"

CHECKED BY

APPROVED BY

PROJECT EMPLOYER

UNITED NATIONS CHILDREN'S FUND

construction section

Renovation of Ghazi Mohamad Jan Khan High school

All dimension are in cm

unicef

Symbol or Legend

Village road

Irrigation Canal

Agriculture land

Houses

flood way

GI Column

Compass

Gutter

Slope

Wash facility water tank

Door

Window

Existence school

Existence Latrine

Trees



PROJECT EMPLOYER
UNITED NATIONS CHILDREN'S FUND
construction section
Renovation of Glazi Mohamad Jan High school
All dimension are in cm


TITLE: GOOGLE MAP "ROAD MAP"

MOHAMMAD HAMAYOON "KARIMI"

DRAWING BY

CHECKED BY


APPROVED BY

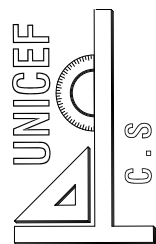


SHEET No	A-3/12
----------	--------

SCALE	AS SHOWN
1	1
2	2
3	3
100	100

DATE	APRIL 2024
------	------------

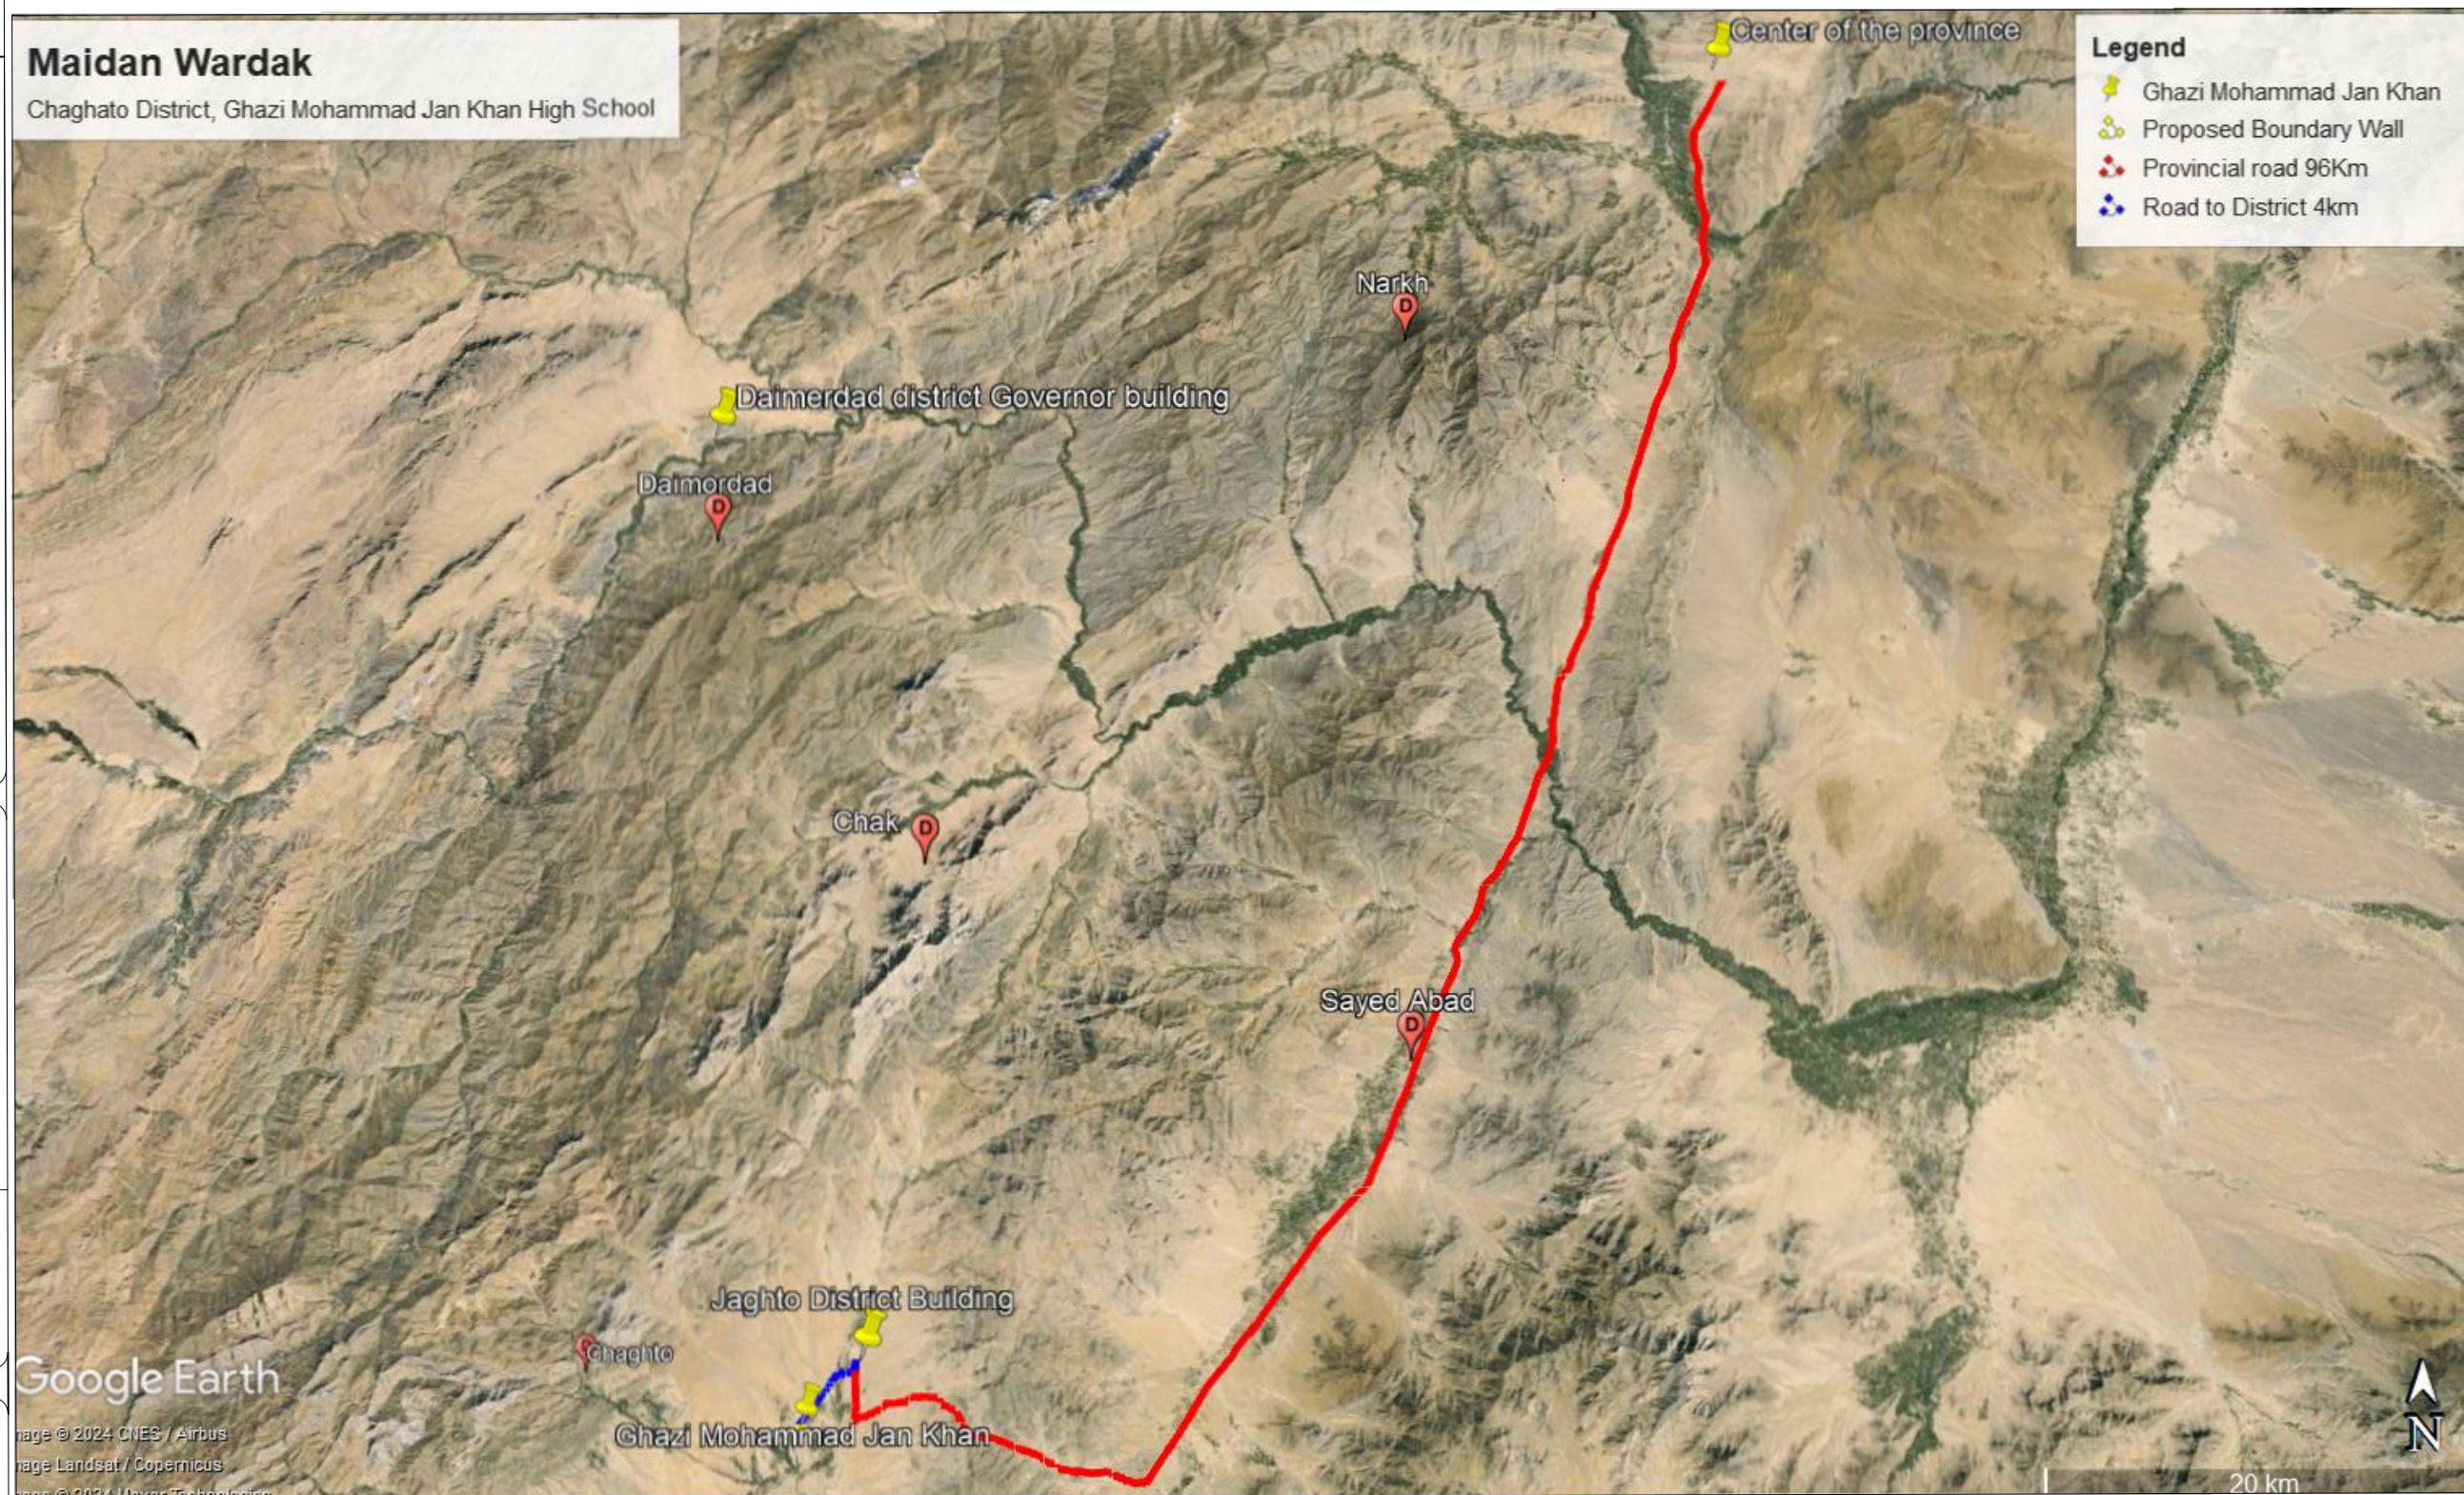

Google Road Map

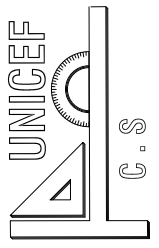


UNICEF

U.S.

SHEET No	A-4/12
SCALE	AS SHOWN
DATE	APRIL . 2024

TITLE : GOOGLE IMAGE SCHOOL AREA		
DRAWING BY	MOHAMMAD HAMAYOON "KARIMI"	
CHECKED BY		
APPROVED BY		

PROJECT EMPLOYER
UNITED NATIONS CHILDREN'S FUND
construction section
Renovation of Ghazi Mohamad Jan High school
All dlimension are in cm

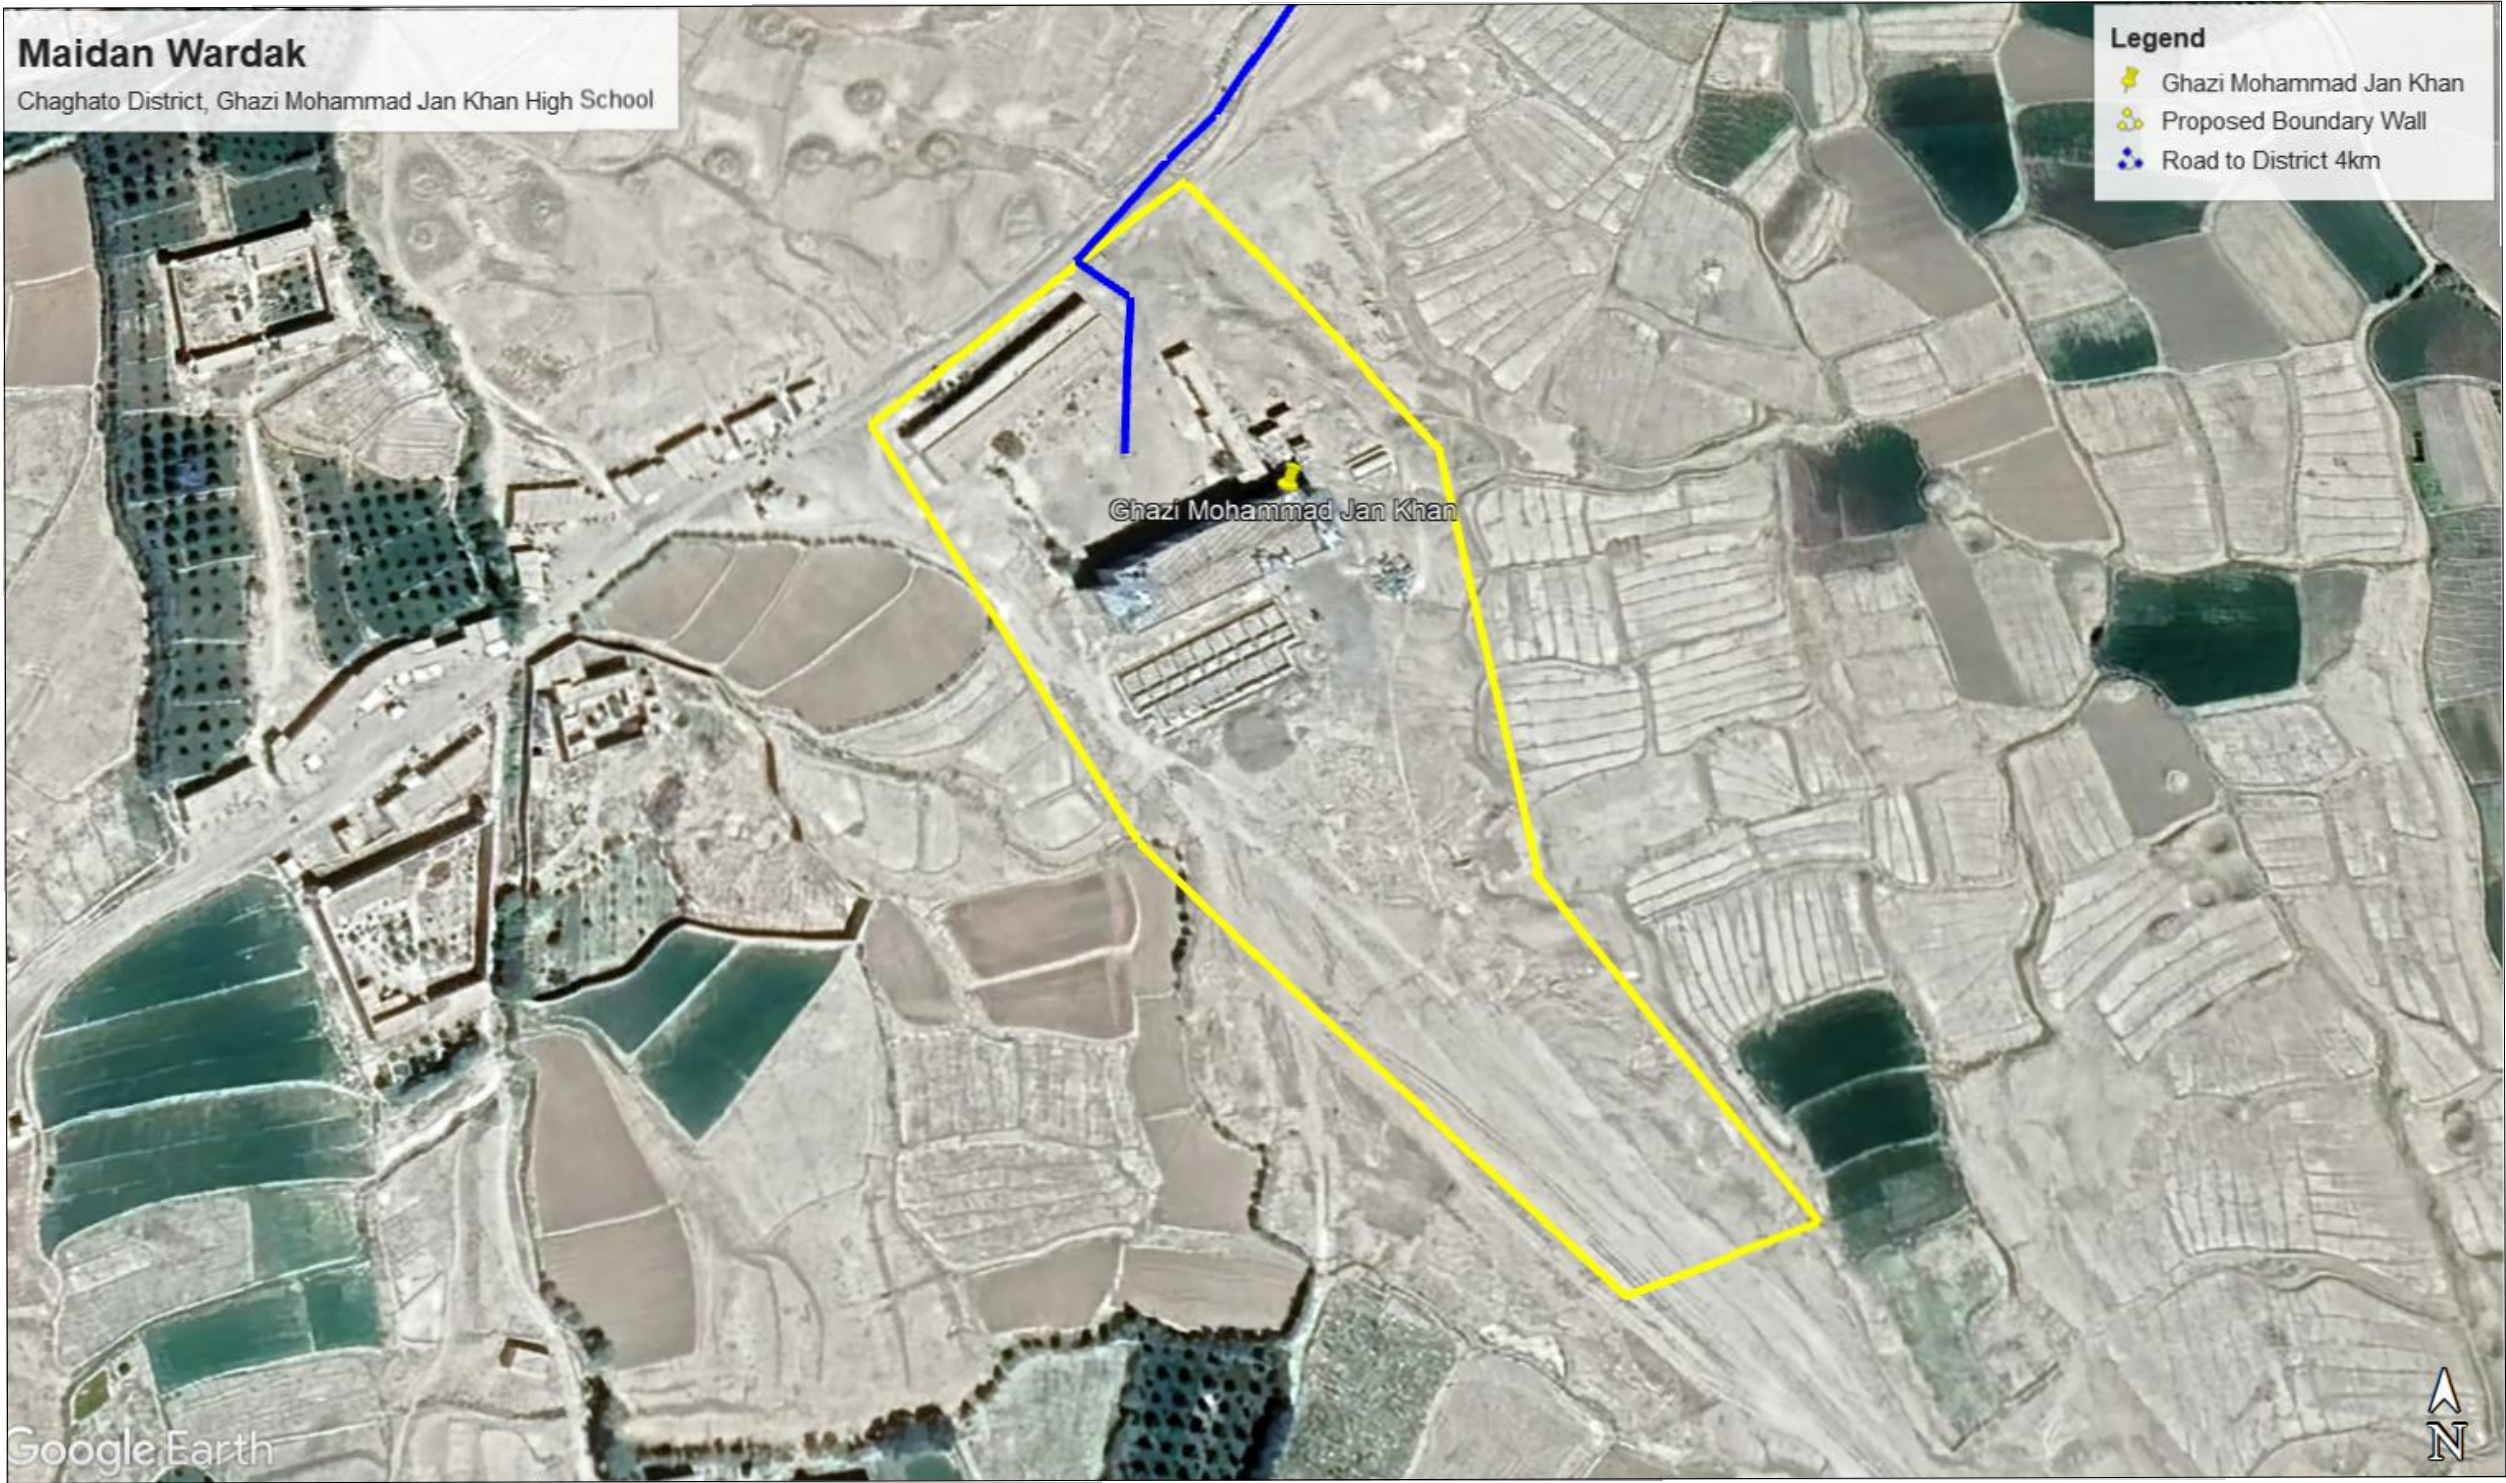

Google Image school area



PROJECT EMPLOYER
UNITED NATIONS CHILDREN'S FUND

construction section

Renovation of Ghazi Moh Jan Khan High School


All dimension are in cm

TITLE : GENERAL SITE PLAN

DRAWING BY	MOHAMMAD HAMAYOON "KARIMI"
------------	----------------------------

CHECKED BY	


APPROVED BY	
-------------	--

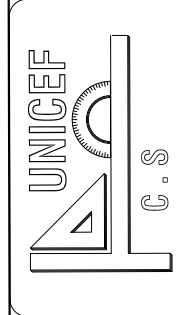

SHEET No	A-5/12
----------	--------

SCALE	AS SHOWN
-------	----------

DATE	April, 2024
------	-------------

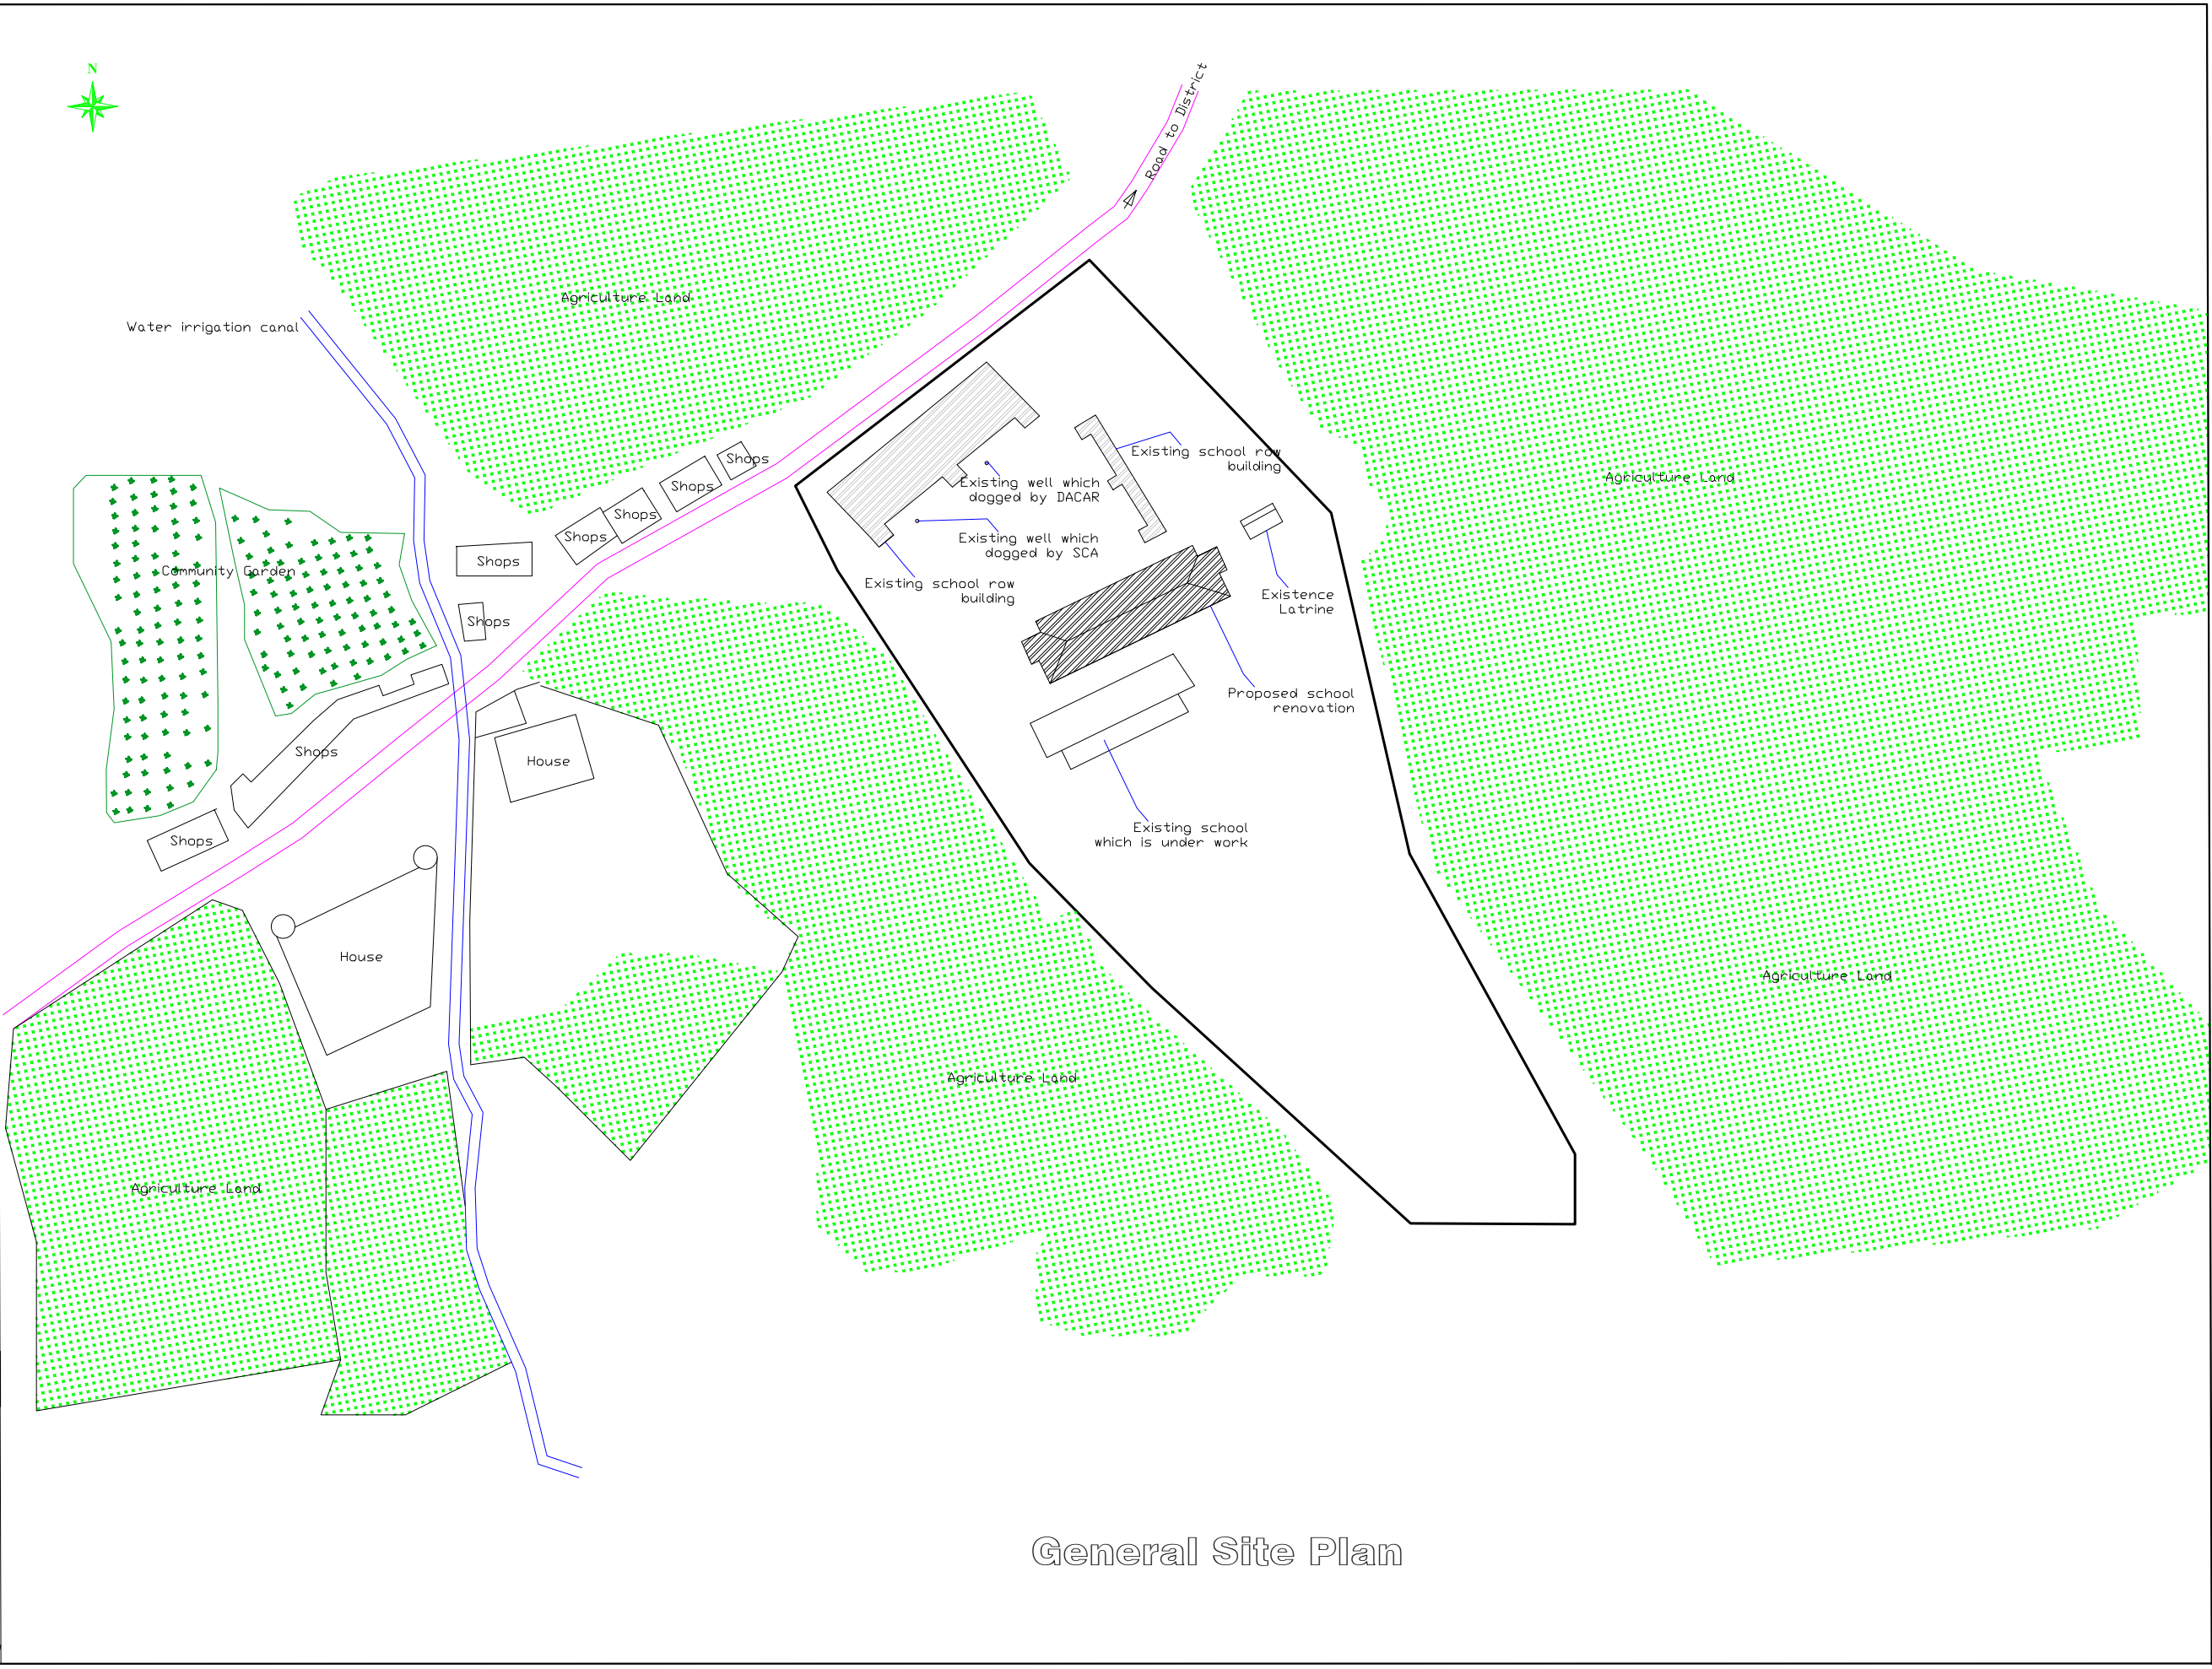

General Site Plan



PROJECT EMPLOYER
UNITED NATIONS CHILDREN'S FUND
construction section
Renovation of Ghazi Moh Jan Khan High School
All dimension are in cm


TITLE: GENERAL SITE PLAN

MOHAMMAD HAMAYOON "KARIMI"

DRAWING BY

CHECKED BY

APPROVED BY

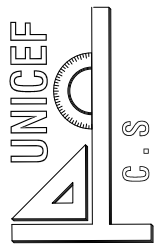


8

SHEET No

A-6/12

SCALE	AS SHOWN
-------	----------


DATE	April. 2024
------	-------------

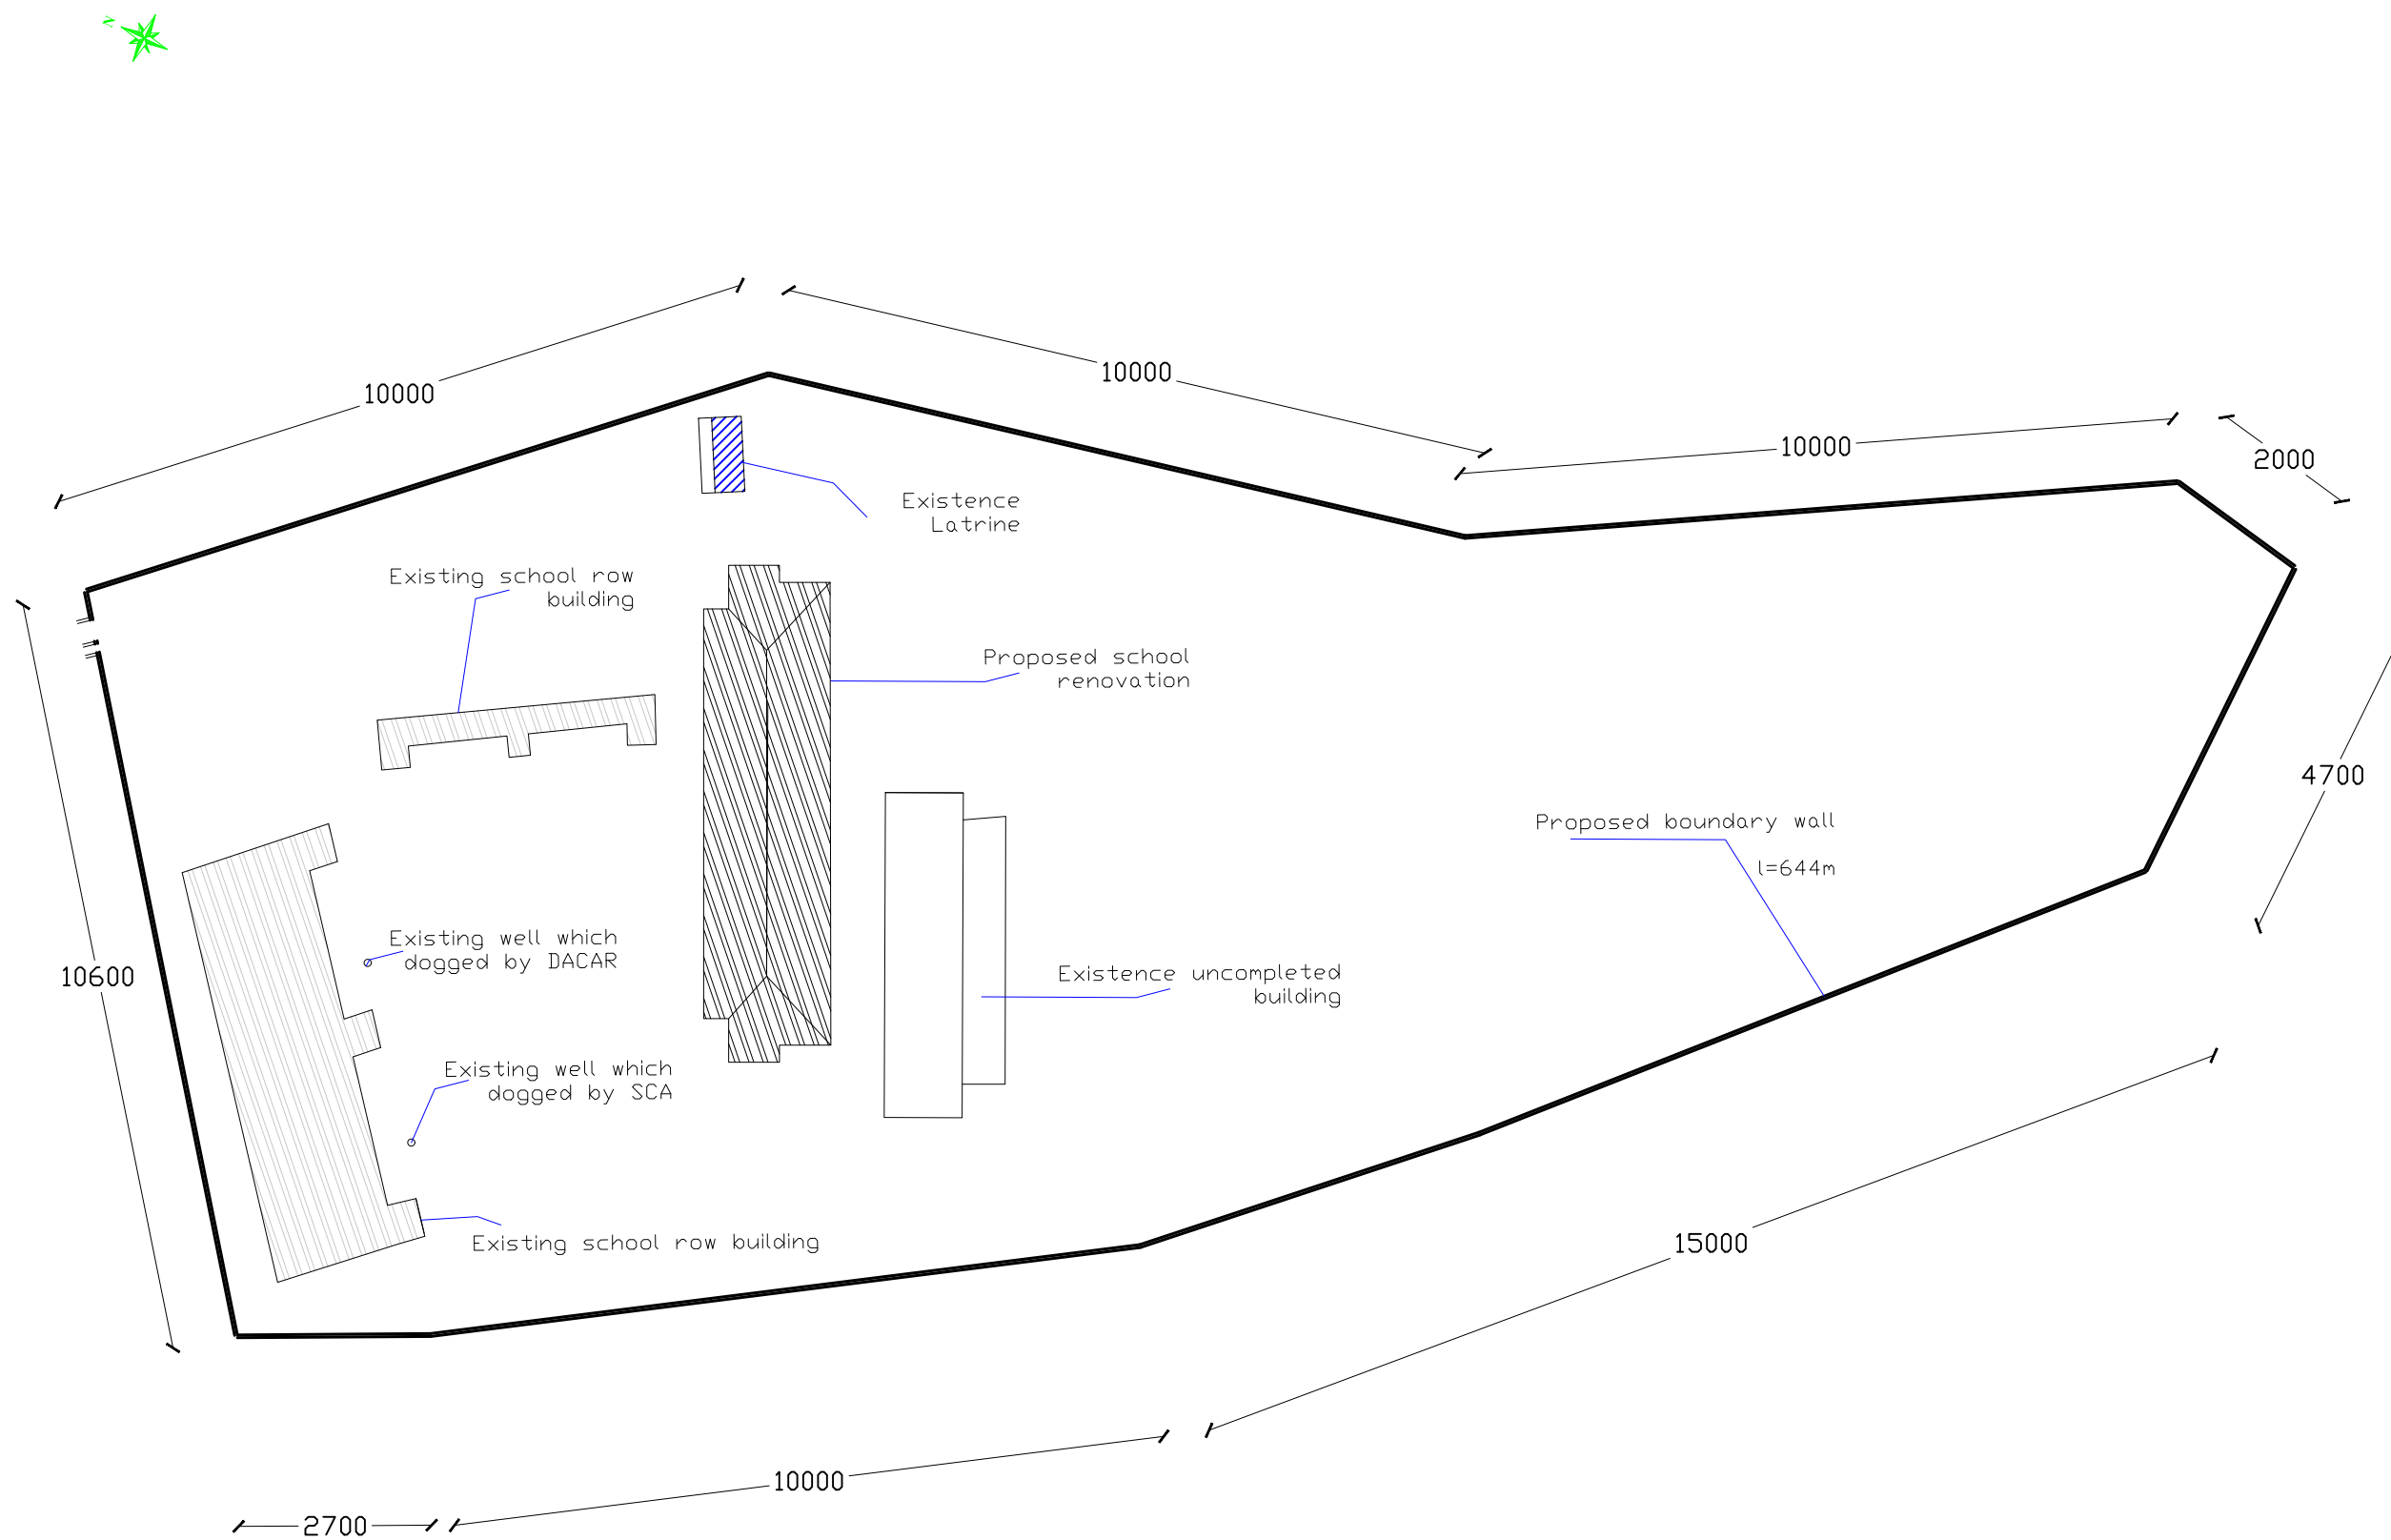



All dimension are in cm


DATE	APRIL. 2024
------	-------------

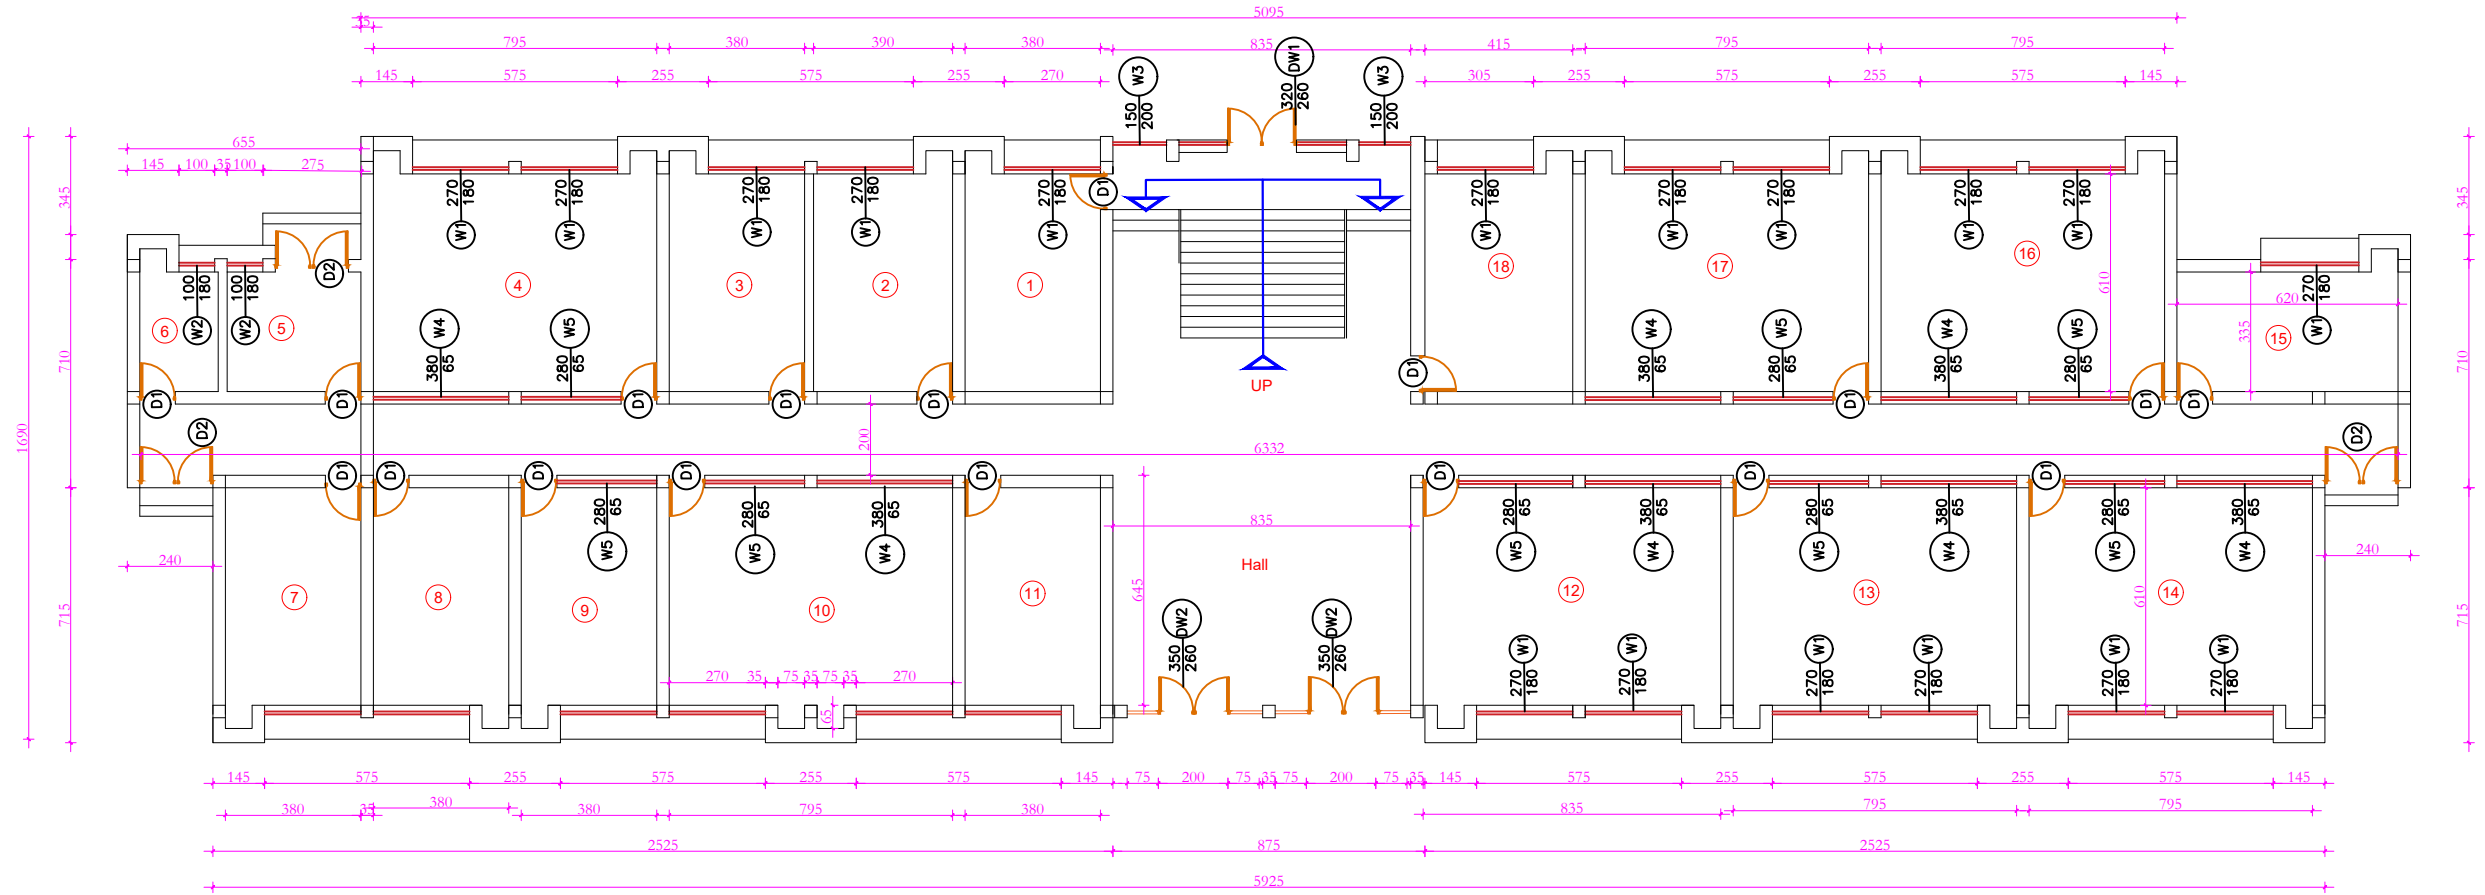

Existence school First Floor plan

Door Window	#	Sizes
D1	18	100 x260 cm
D2	3	200 x260 cm
Dw1	2	320 x200 cm
Dw2	2	350 x260 cm
W1	23	270 x180 cm
W2	2	100 x180 cm
W3	2	150x200 cm
W4	7	380x65 cm
W5	8	280x65 cm
H		320cm

UNICEF



C.S

SHEET No

A-8/12

SCALE

AS SHOWN

DATE

APRIL 2024

TITLE :

SCHOOL PLAN SECOND T FLOOR

DRAWING BY

MOHAMMAD HAMAYOON "KARIMI"

CHECKED BY

APPROVED BY


PROJECT EMPLOYER

UNITED NATIONS CHILDREN'S FUND

constuction section


Renovation of Ghazi Moh Jan Khan High School

All dimention are in cm

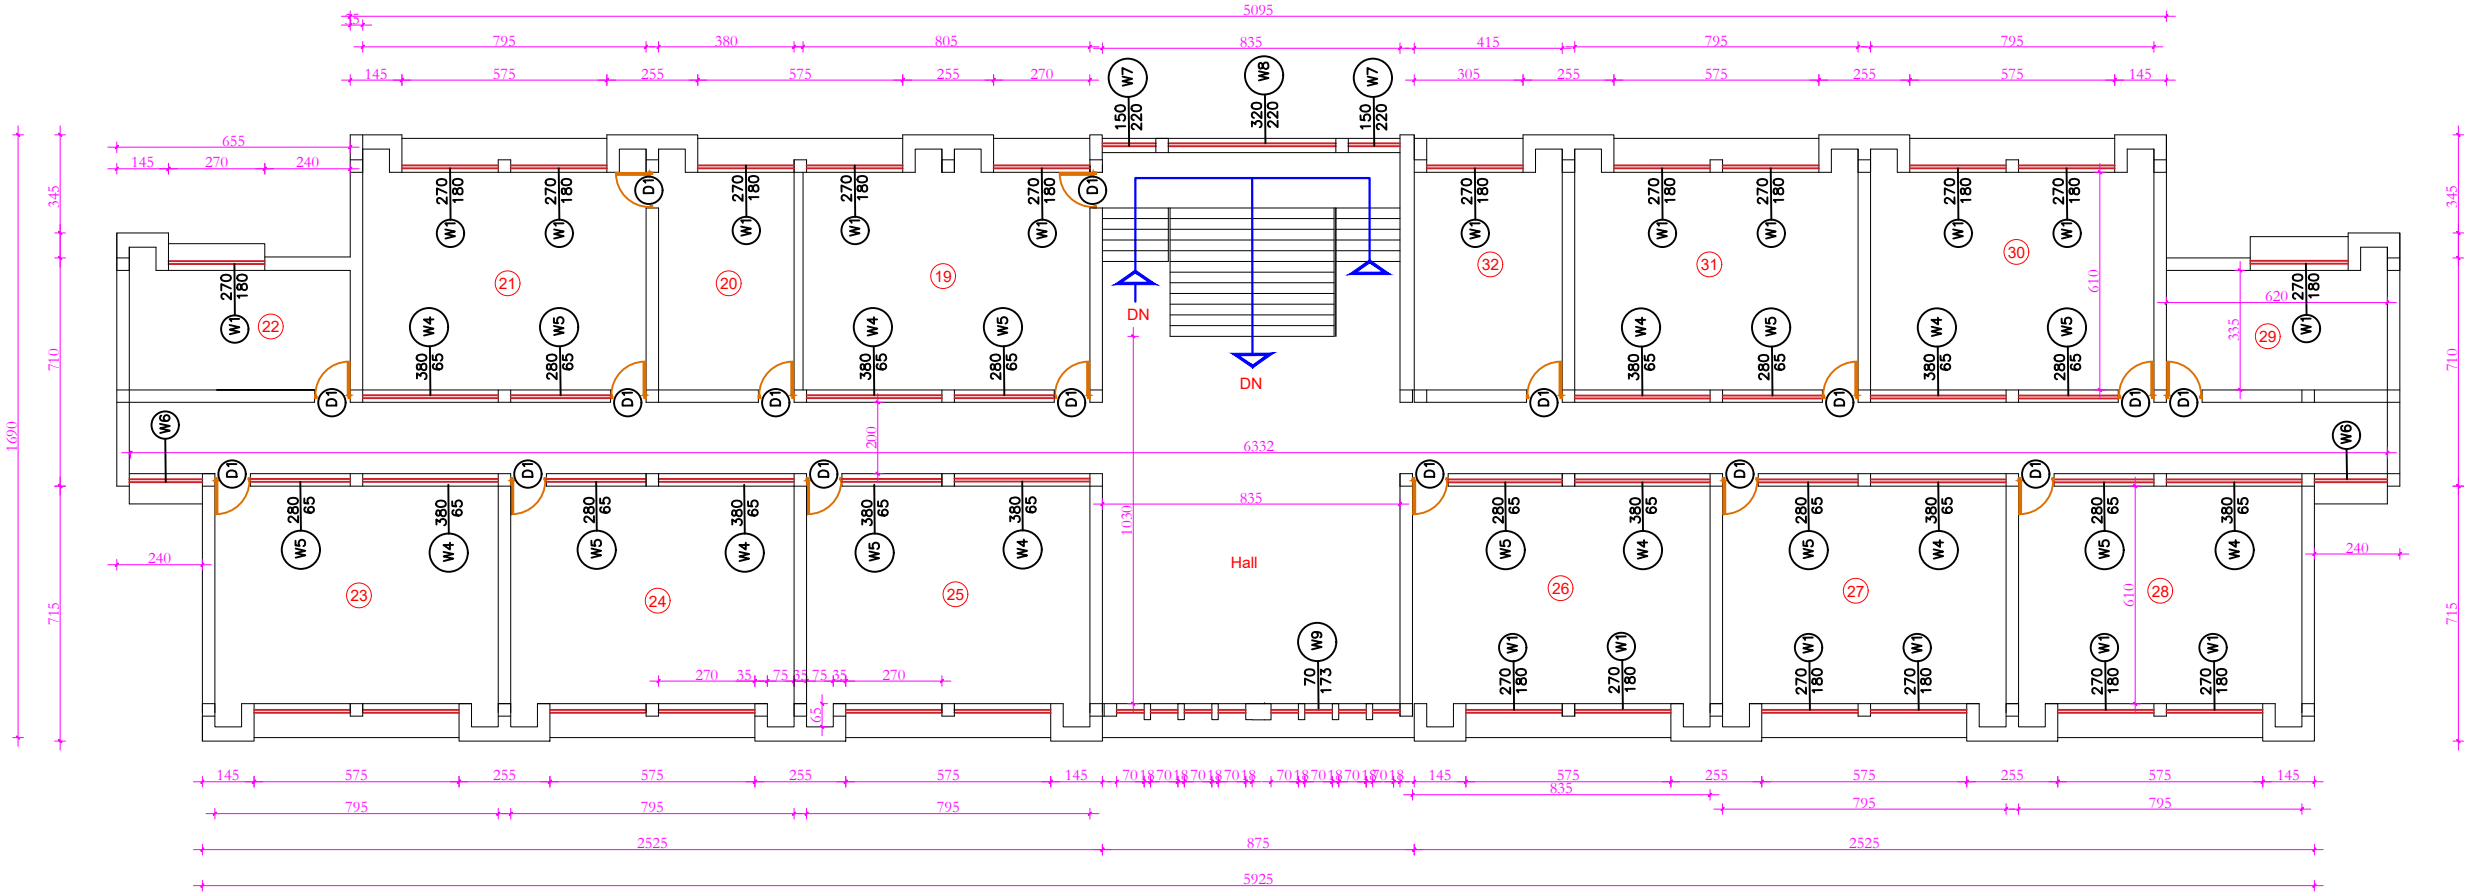


Existence school Second Floor plan

Door Window	#	Sizes
D1	14	100 x260 cm
W1	24	270 x180 cm
W4	10	380x65 cm
W5	10	280x65 cm
W6	2	200 x180 cm
W7	2	150x220 cm
W8	1	320 x220 cm
W9	8	70 x175 cm
H		320cm

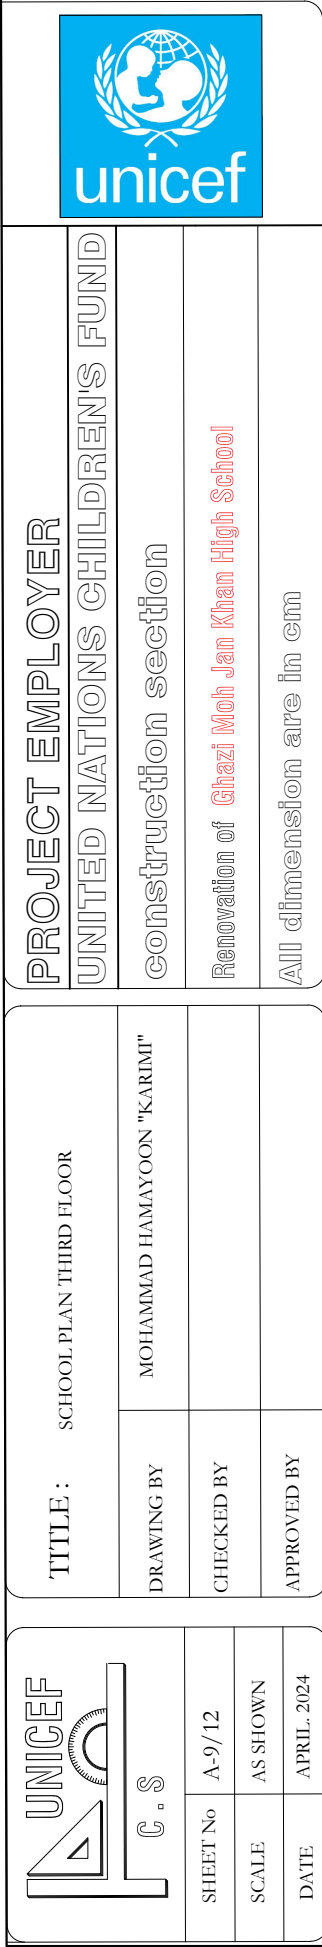

Door Window	#	Sizes
D1	14	100 x260 cm
W1	24	270 x180 cm
W4	10	380x65 cm
W5	10	280x65 cm
W6	2	200 x180 cm
W7	2	150x220 cm
W8	1	320 x220 cm
W9	8	70 x175 cm
H		320cm




PROJECT EMPLOYER
UNITED NATIONS CHILDREN'S FUND
construction section
Renovation of Ghazi Mohamad Jan High school
All dimension are in cm

TITLE :
EXISTENCE TRUSS SECTION

DRAWING BY
MOHAMMAD HAMAYOON "KARIMI"

CHECKED BY

APPROVED BY



C.S

SHEET No
A-10/12

SCALE
AS SHOWN

DATE
APRIL 2024

Detail A

Existence board 2cm 10+15cm
Proposed 80% of the mentioned board

Existence top truss wooden beam 8x4 cm

Existence wooden beam 6x4 cm

Proposed corrugated GI sheet 0.5mm)

Existence truss wooden beam 10x6 cm

870

870

66

160

85

15

10

35

60

35

610

200

610

35

60

Existence truss frame

Existence board 2cm 10+15cm
Proposed 80% of the mentioned board

Proposed corrugated GI sheet 0.5mm)

Existence Straw mud plaster 5cm

Existence truss wooden beam 10x6 cm

Existence RCC parapet
need repairing

85

15


10

35

60

35

Detail A-A

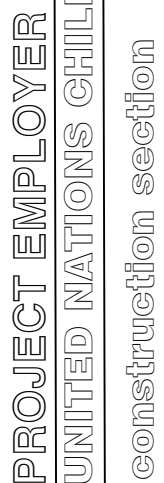

Renovation of Ghazi Moh Jan Khan High School


All dimension are in cm

TITLE:
SCHOOL PLAN FIRST FLOOR
ELECTRICAL PLAN

MOHAMMAD HAMAYOON "KARIMI"

CHECKED BY


APPROVED BY

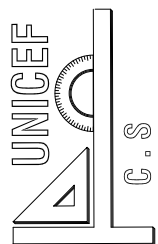







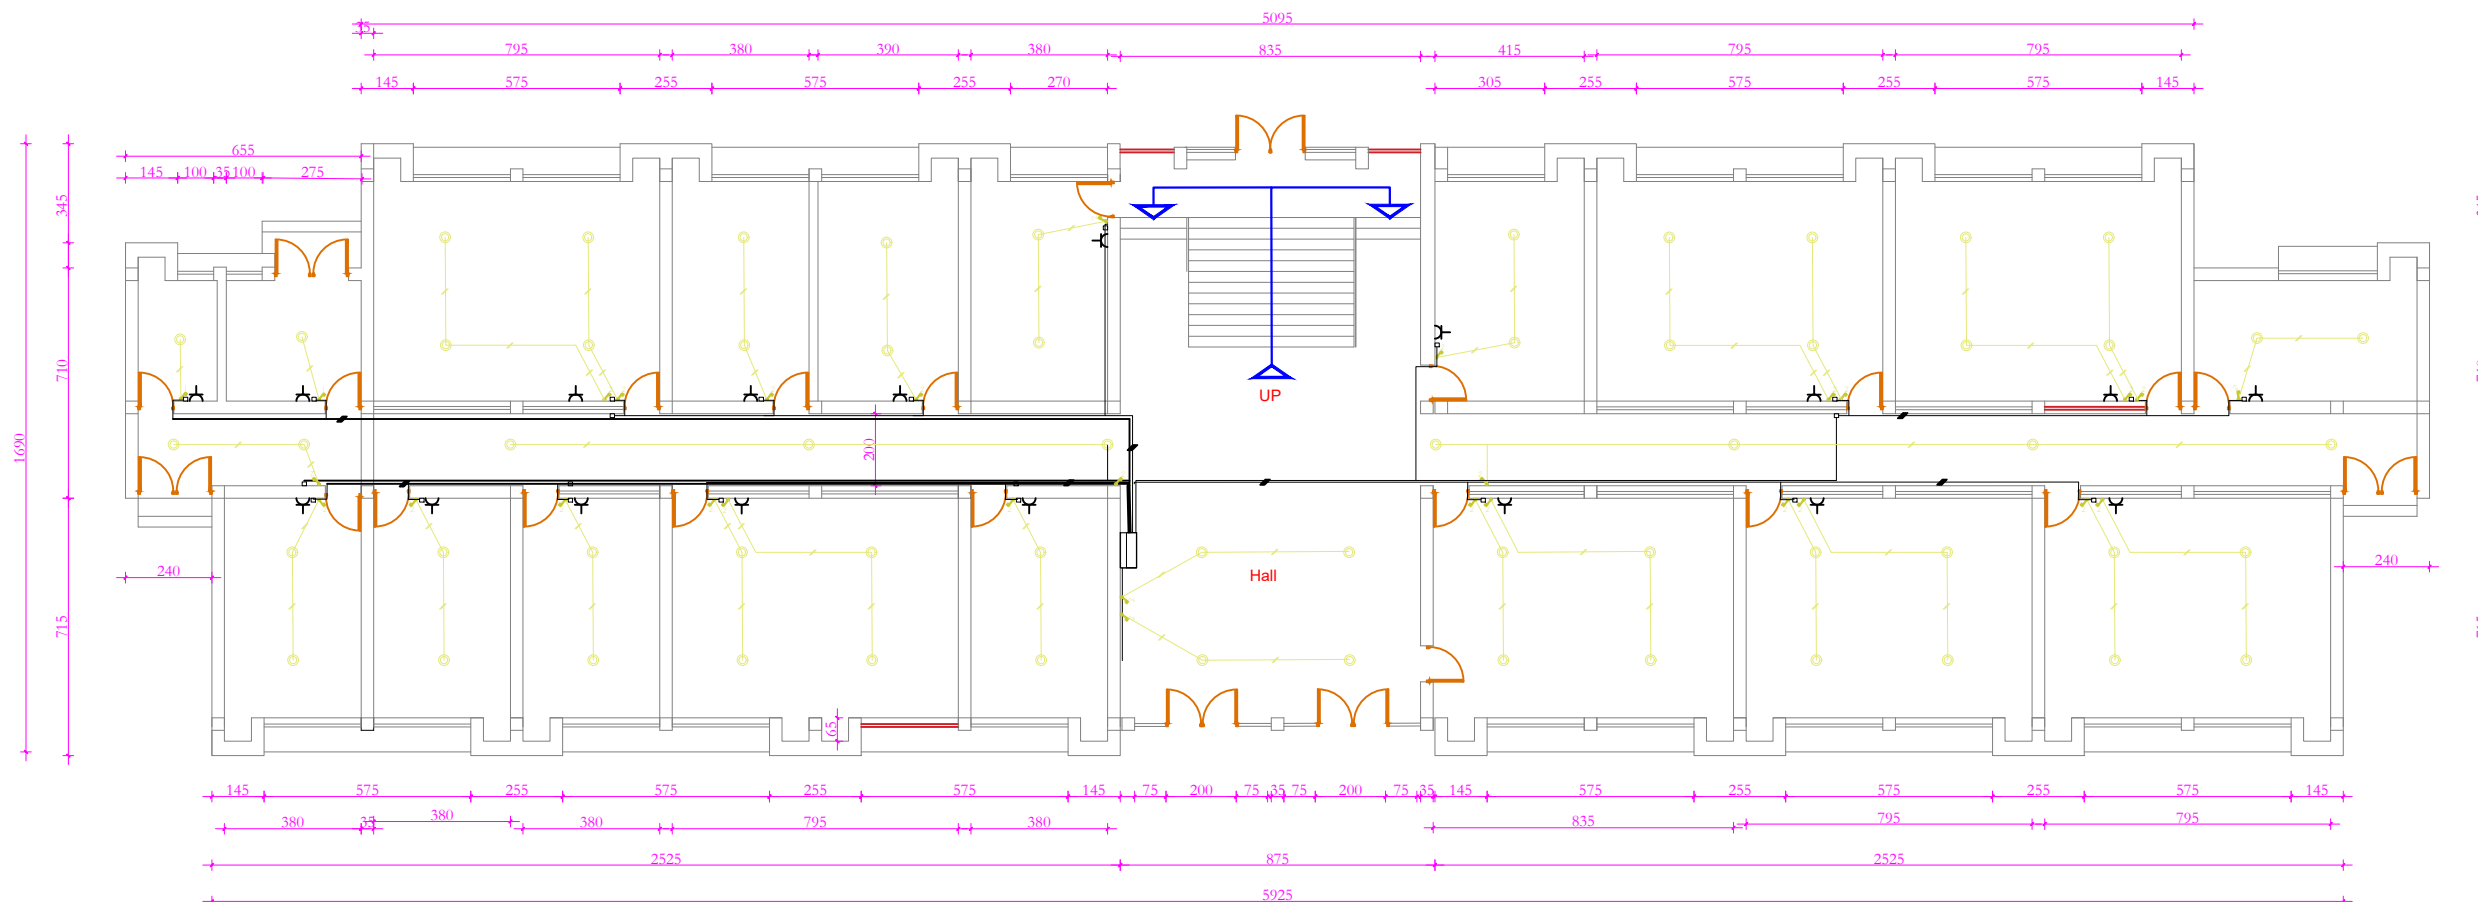




SHEET No A-11/12


SCALE	AS SHOWN
-------	----------

DATE	APRIL, 2024
------	-------------



Existence school First Floor Electrical plan

SPECIFICATION					
NO.	DESCRIPTION	SIGNS	UNIT	PIECES	REMARKS
1	CEILING LED LIGHT 1x16w		NO	156	
2	SOCKET OUTLET - SINGLE PHASE		NO	40	
3	SWITCHES UNDER PLASTER ONE POLE		NO	6	
4	DOUBLE/TWO POLE SWITCHES UNDER PLASTER		NO	81	
5	WIRE 1/2x1.5mm TYPE NYF		M	790	
6	WIRE 1/2x2.5mm TYPE NYF		M	900	
7	CABLE 1/2x4mm FOR Connection of building TYPE NYF		M	25	
8	FUSE BOX FOR 4 FUSE		NO	3	
9	Joint Box		NO	69	
10	FUSE 30A		NO	3	
11	FUSE 20A		NO	12	

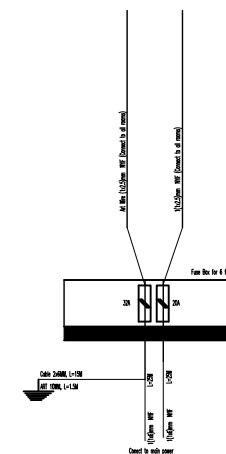

UNICEF

C.S

SHEET No

A-12/12

SCALE

AS SHOWN

DATE

APRIL 2024

TITLE :

LATRINE EXISTENCE PLAN

DRAWING BY

MOHAMMAD HAMAYOON "KARIMI"

CHECKED BY

APPROVED BY


PROJECT EMPLOYER

UNITED NATIONS CHILDREN'S FUND

construction section

Renovation of Ghazi Mohamad Jan Khan High School

All dimension are in cm



860

35 119 119 119 119 119 35

395

155 240 100

45 110 25 35 100

W3

D3

83 100 95 100 113 120 250

860

Door Window	#	Sizes
D3	6	80 x250 cm
W3	6	50 x50 cm
H		300 cm

Existing latrine Plan