




PROJECT NAME : RENOVATION OF ( **Kalan deh High school** )

PROJECT EMPLOYER : UNITED NATIONS CHILDREN'S FUND

PREPARE BY : CONSTRUCTION SECTION




PROJECT EMPLOYER  
UNITED NATIONS CHILDREN'S FUND  
construction section  
Renovation of *Kalan dah High school*  
All dimension are in cm

TITLE : TABLE OF CONTENTS

DRAWING BY  
MOHAMMAD HAMAYOON "KARIMI"

CHECKED BY

APPROVED BY

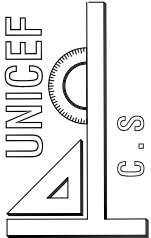


C.S

SHEET No  
A-1/10

SCALE  
AS SHOWN

DATE  
APRIL 2024

S.N	TABLE OF CONTENTS
A- 1/10	TABLE OF CONTENTS
A- 2/10	MATERIALS SYBOLS
A- 3/10	GOOGLE MAP "ROAD MAP"
A- 4/10	GOOGLE SCHOOL IMAGE
A- 5/10	GENERAL SITE PLAN
A- 6/10	SCHOOL SITE PLAN
A- 7/10	SCHOOL FIRST FLOOR PLAN
A- 8/10	SCHOOL SECOND FLOOR PLAN
A- 9/10	SCHOOL TYPICAL ELECTRICAL FLOOR PLAN
A- 10/10	LATRINE PALN

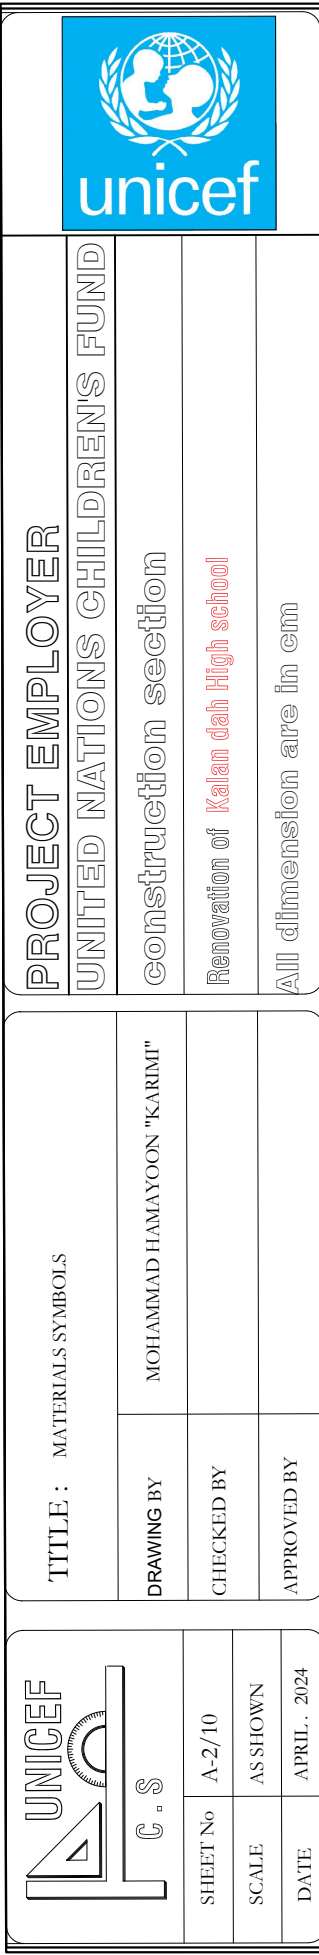



UNICEF

C.S.

SHEET No

SCALE

DATE

A-3/10

AS SHOWN

APRIL 2024

TITLE : GOOGLE MAP "ROAD MAP"

DRAWING BY

CHECKED BY

APPROVED BY

MOHAMMAD HAMAYOON "KARIMI"


PROJECT EMPLOYER

UNITED NATIONS CHILDREN'S FUND

construction section

Renovation of Kalan dah High school

All dimension are in cm



unicef

**Wardak Province**  
Kalandah High School Jaghto District

**Legend**

- Jaghto District Building
- Road from district to School
- Road to District
- Proposed Boundary wall


Locations marked on the map: Jaghto District Building, Center of the province, Maidan Shar, Narkh, Daimordad, Chak, Sayed Abad, Chaghto.

Google Earth

N

Google Road Map



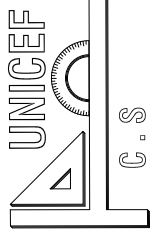


UNICEF

U.S.

SHEET No	A-4/10
SCALE	AS SHOWN
DATE	APRIL . 2024

TITLE :    GOOGLE IMAGE SCHOOL AREA		
DRAWING BY	MOHAMMAD HAMAYOON "KARIMI"	
CHECKED BY		
APPROVED BY		

PROJECT EMPLOYER
UNITED NATIONS CHILDREN'S FUND
construction section
Renovation of <i>Kalan dah High school</i>
All dimension are in cm

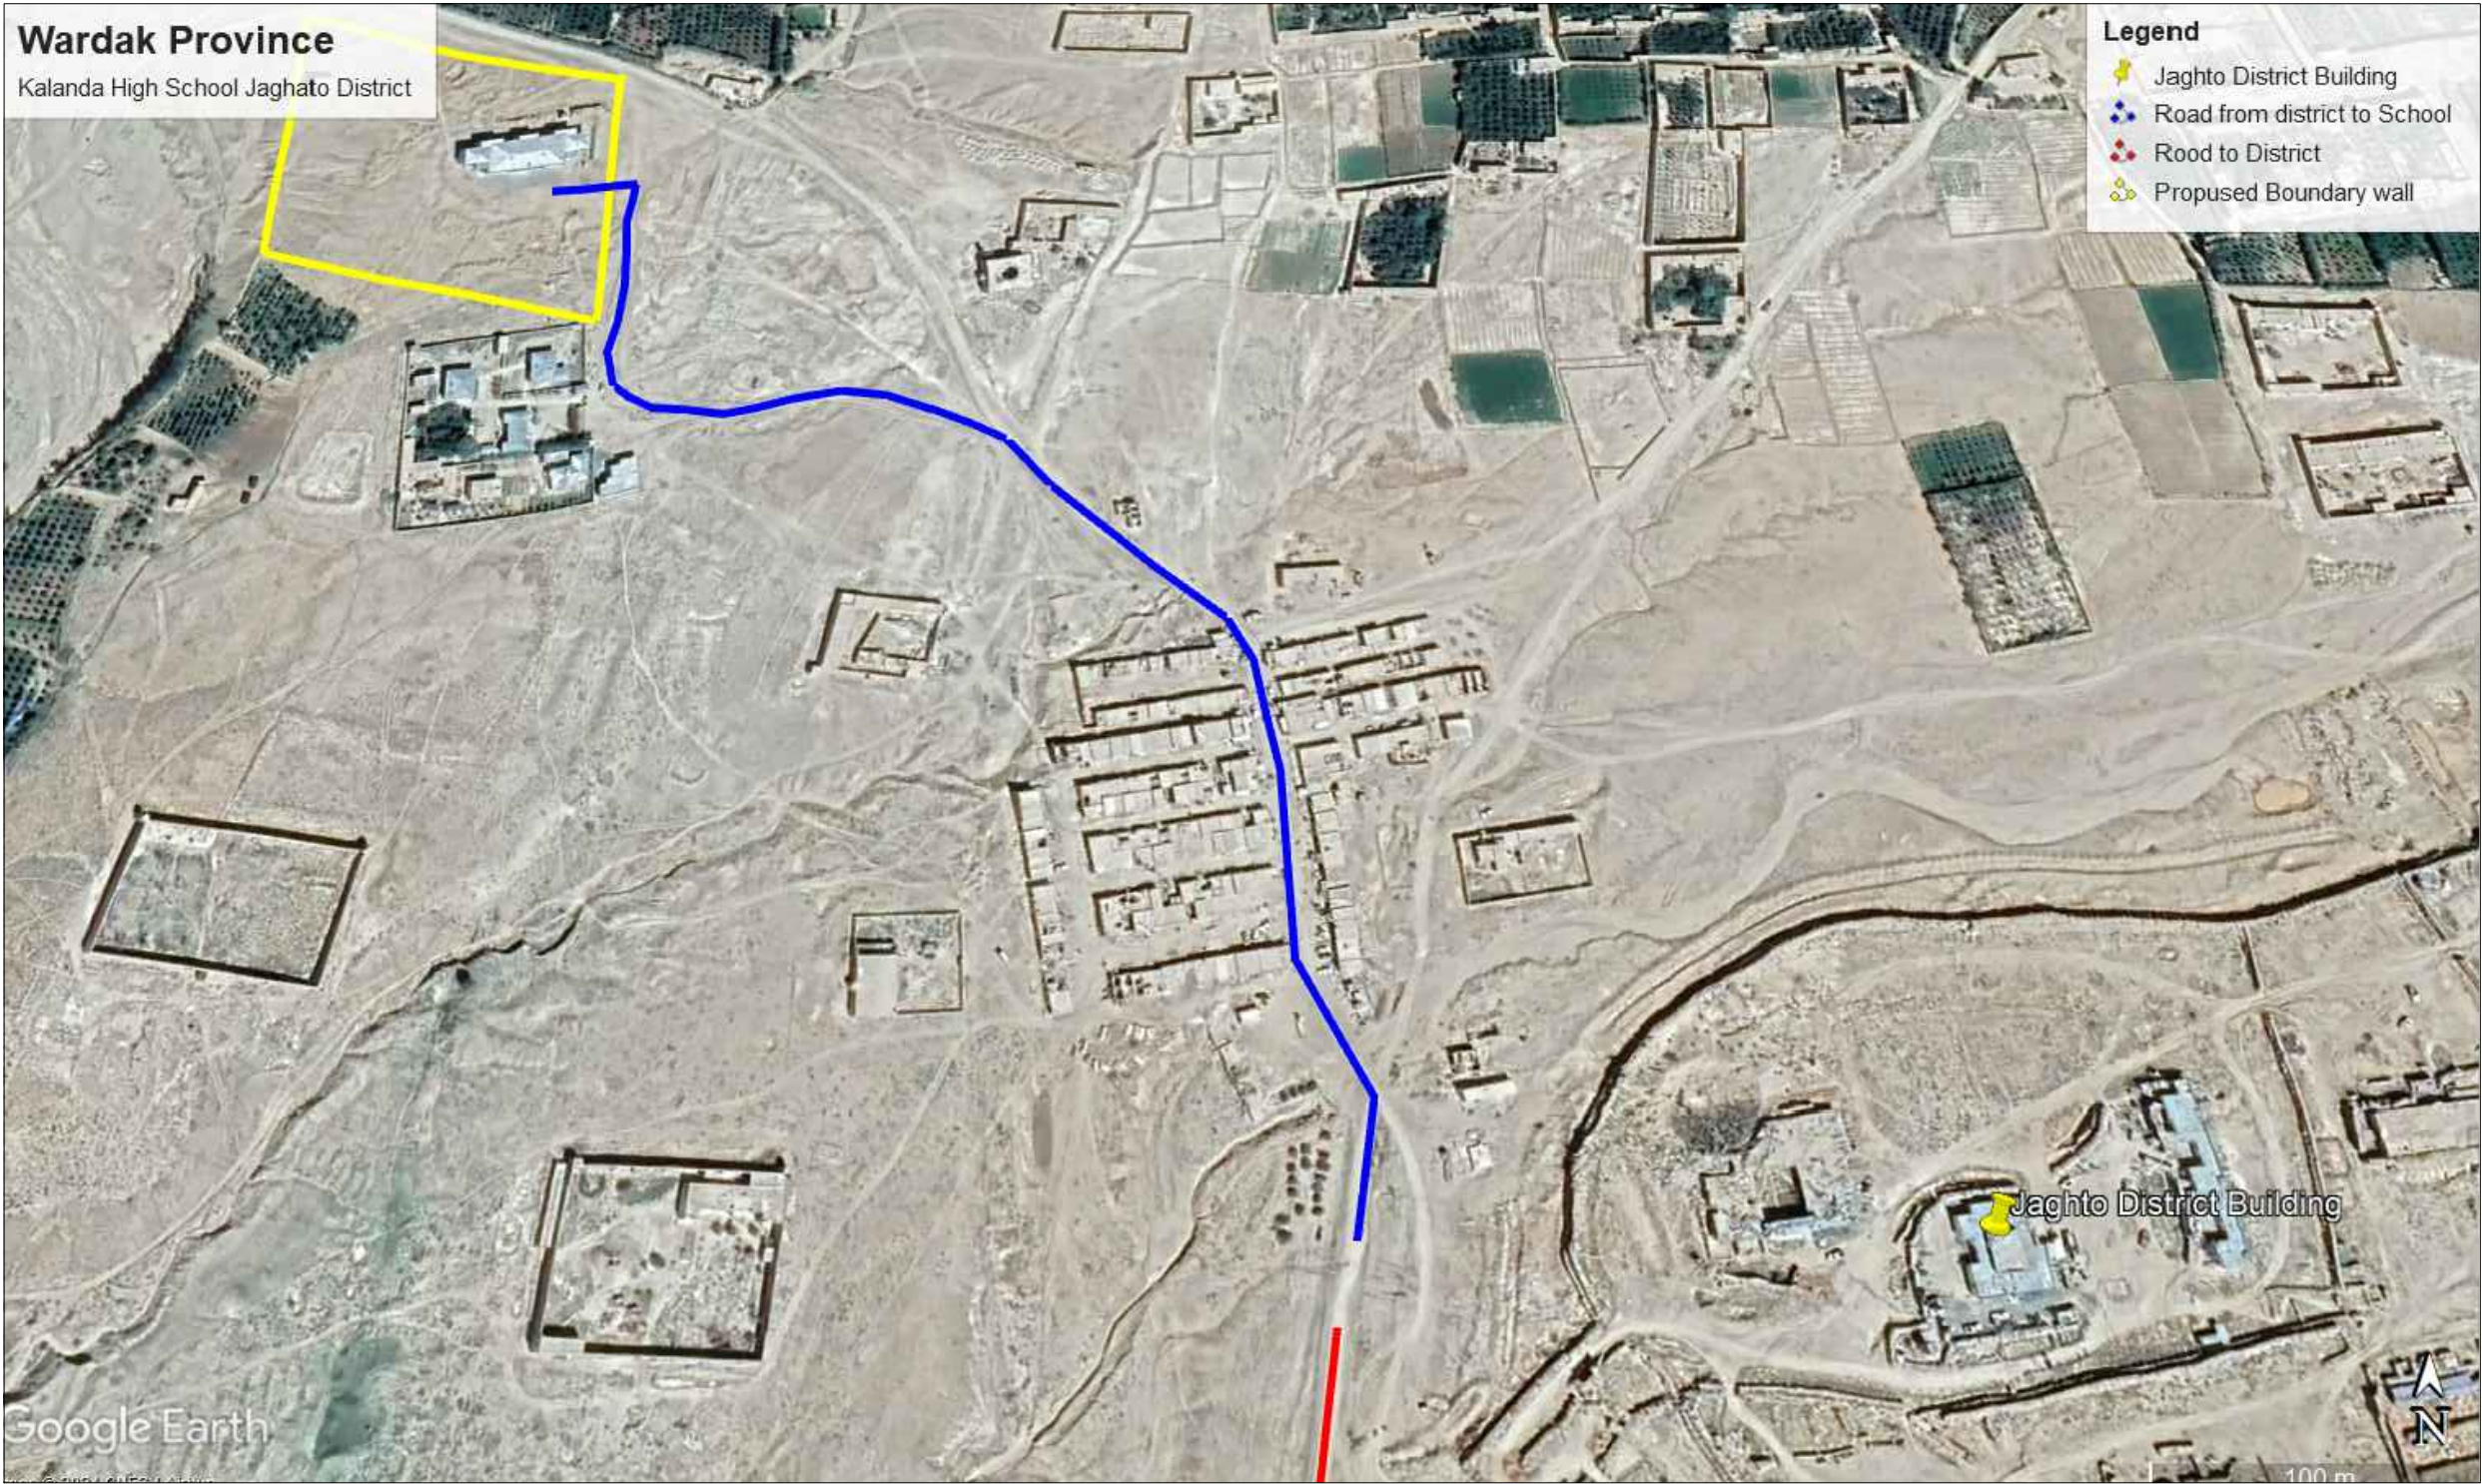


Google Image school area






PROJECT EMPLOYER
UNITED NATIONS CHILDREN'S FUND
construction section
Renovation of <b>Kalan dah High school</b>
All dimension are in cm


TITLE : GENERAL SITE PLAN	
DRAWING BY	MOHAMMAD HAMAYOON "KARIMI"
CHECKED BY	
APPROVED BY	

	SHEET No		A-5/10
	SCALE		AS SHOWN
	DATE		April. 2024

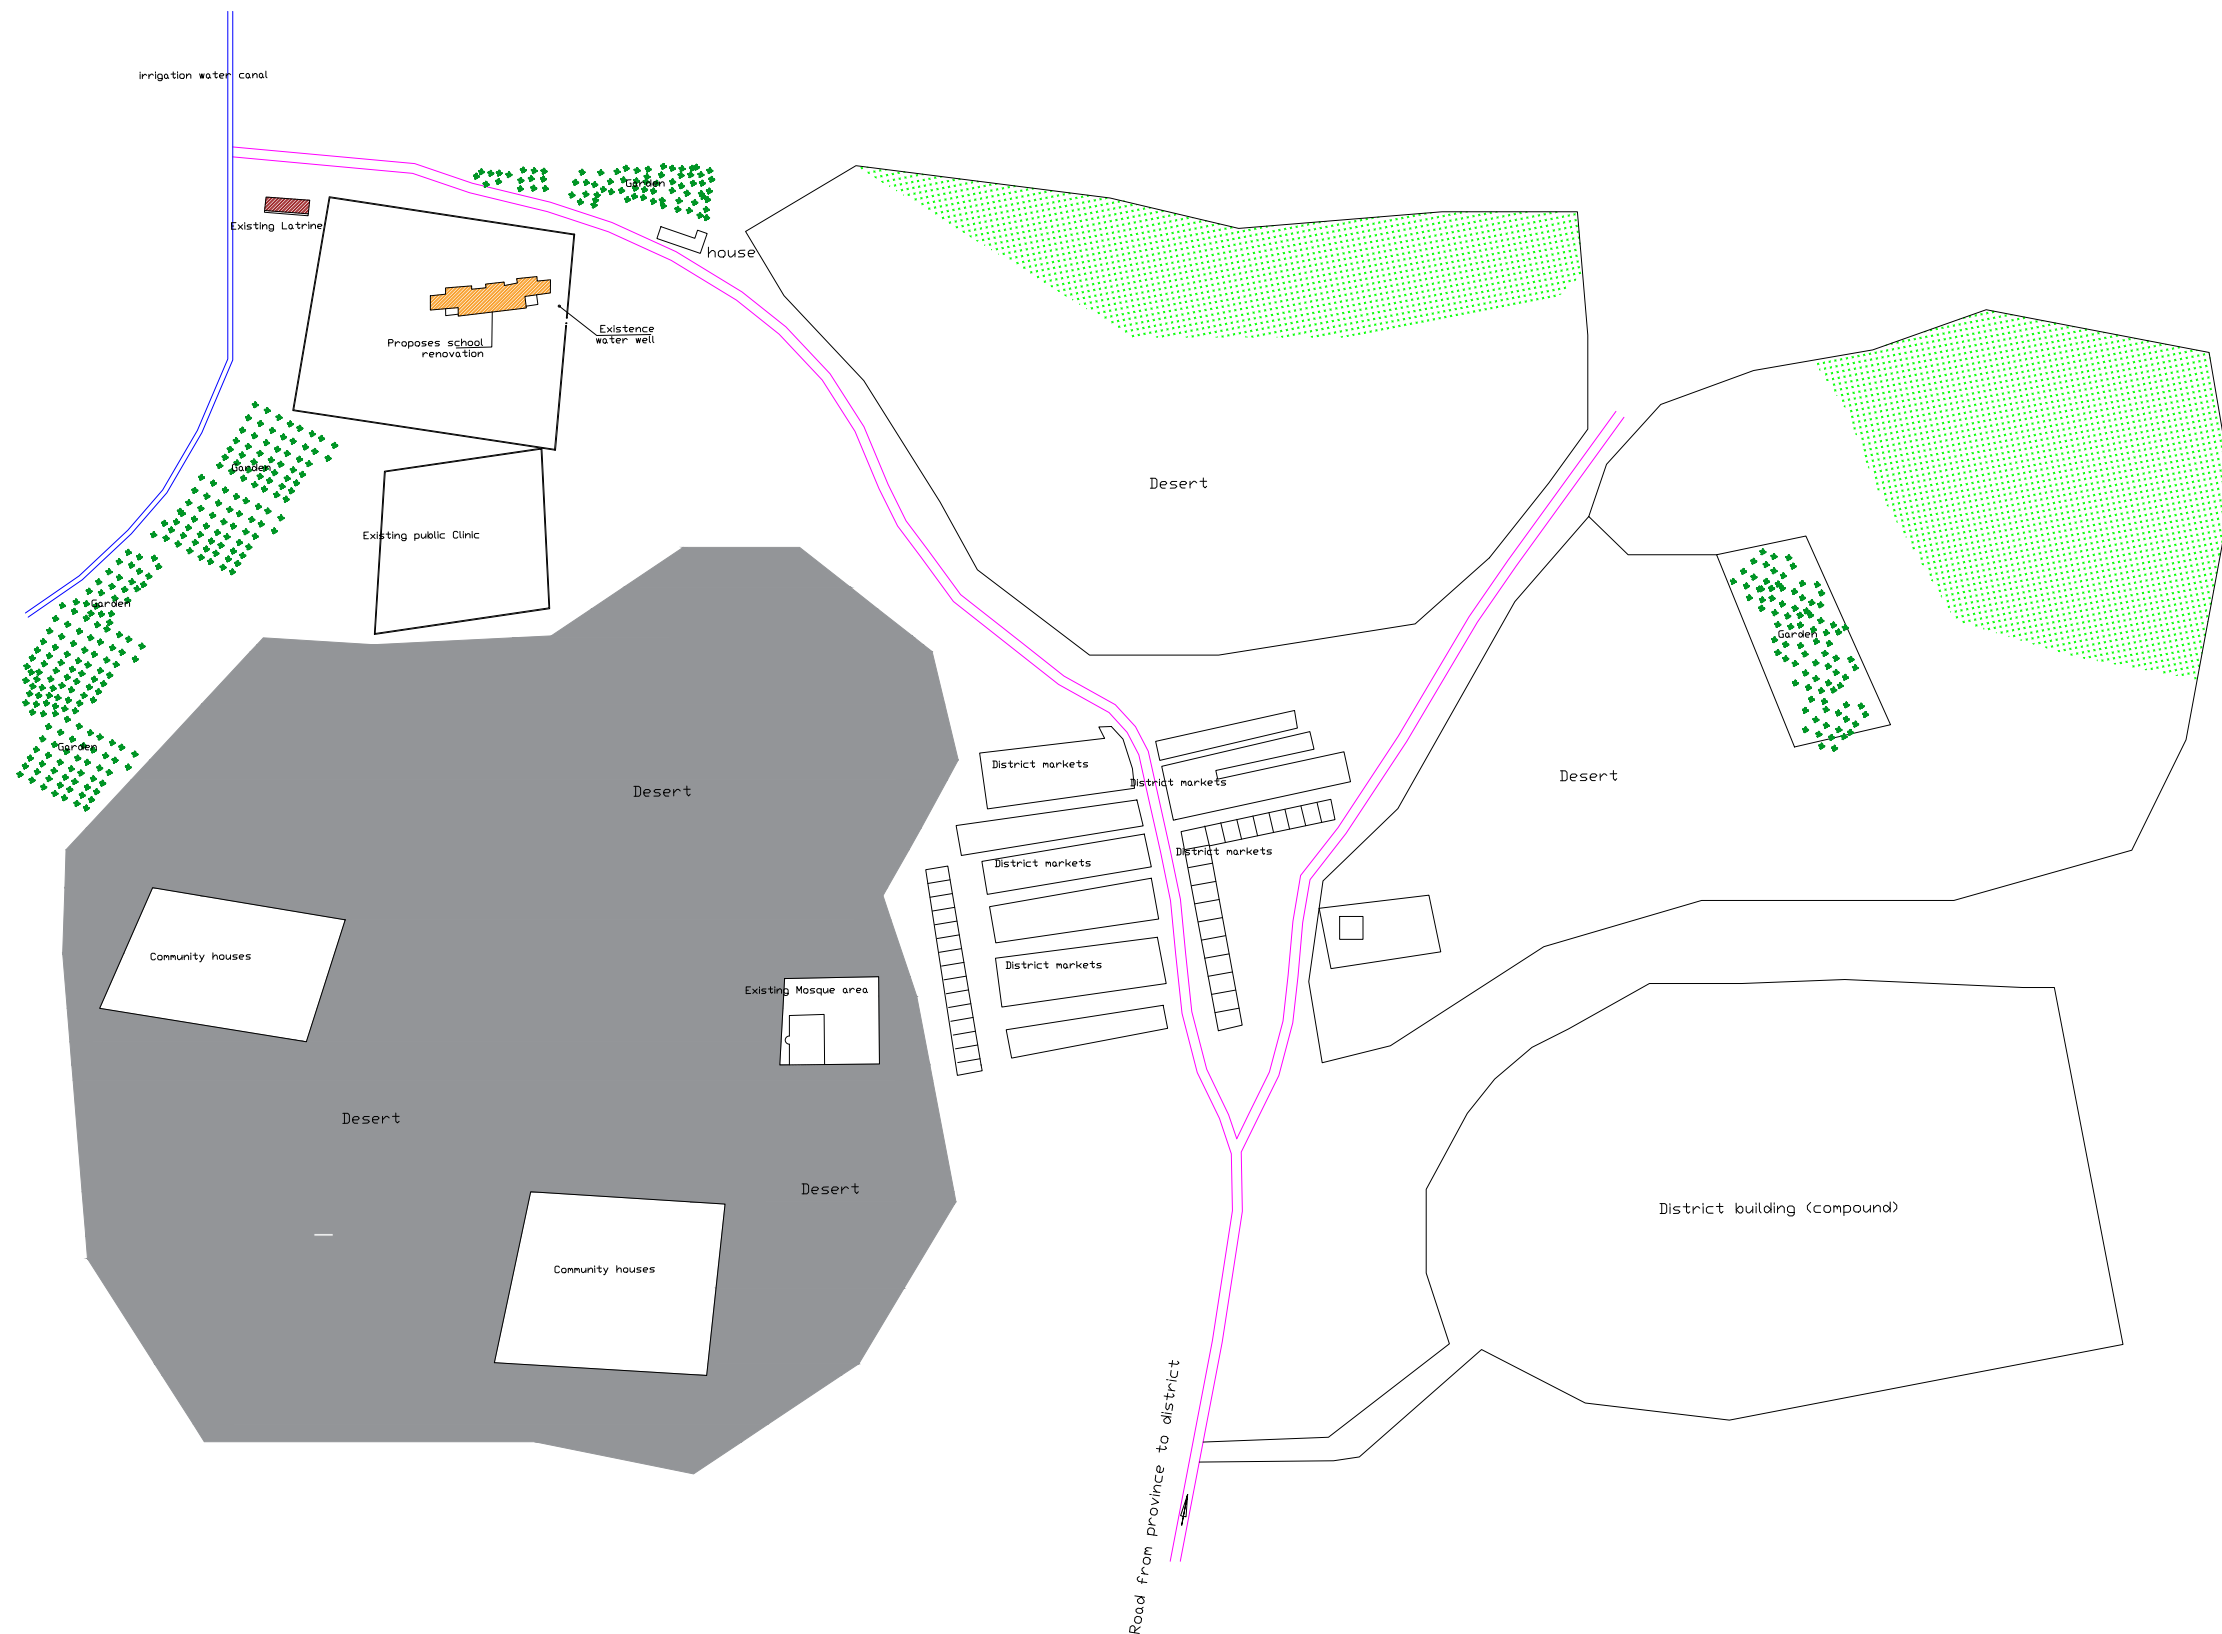

# General Site Plan

UNICEF




C.S

SHEET No	A-6/10
SCALE	AS SHOWN
DATE	April 2024

TITLE : GENERAL SITE PLAN	
DRAWING BY	MOHAMMAD HAMAYOON "KARIMI"
CHECKED BY	
APPROVED BY	

PROJECT EMPLOYER
UNITED NATIONS CHILDREN'S FUND
construction section
Renovation of <b>Kalan dah High school</b>
All dimension are in cm

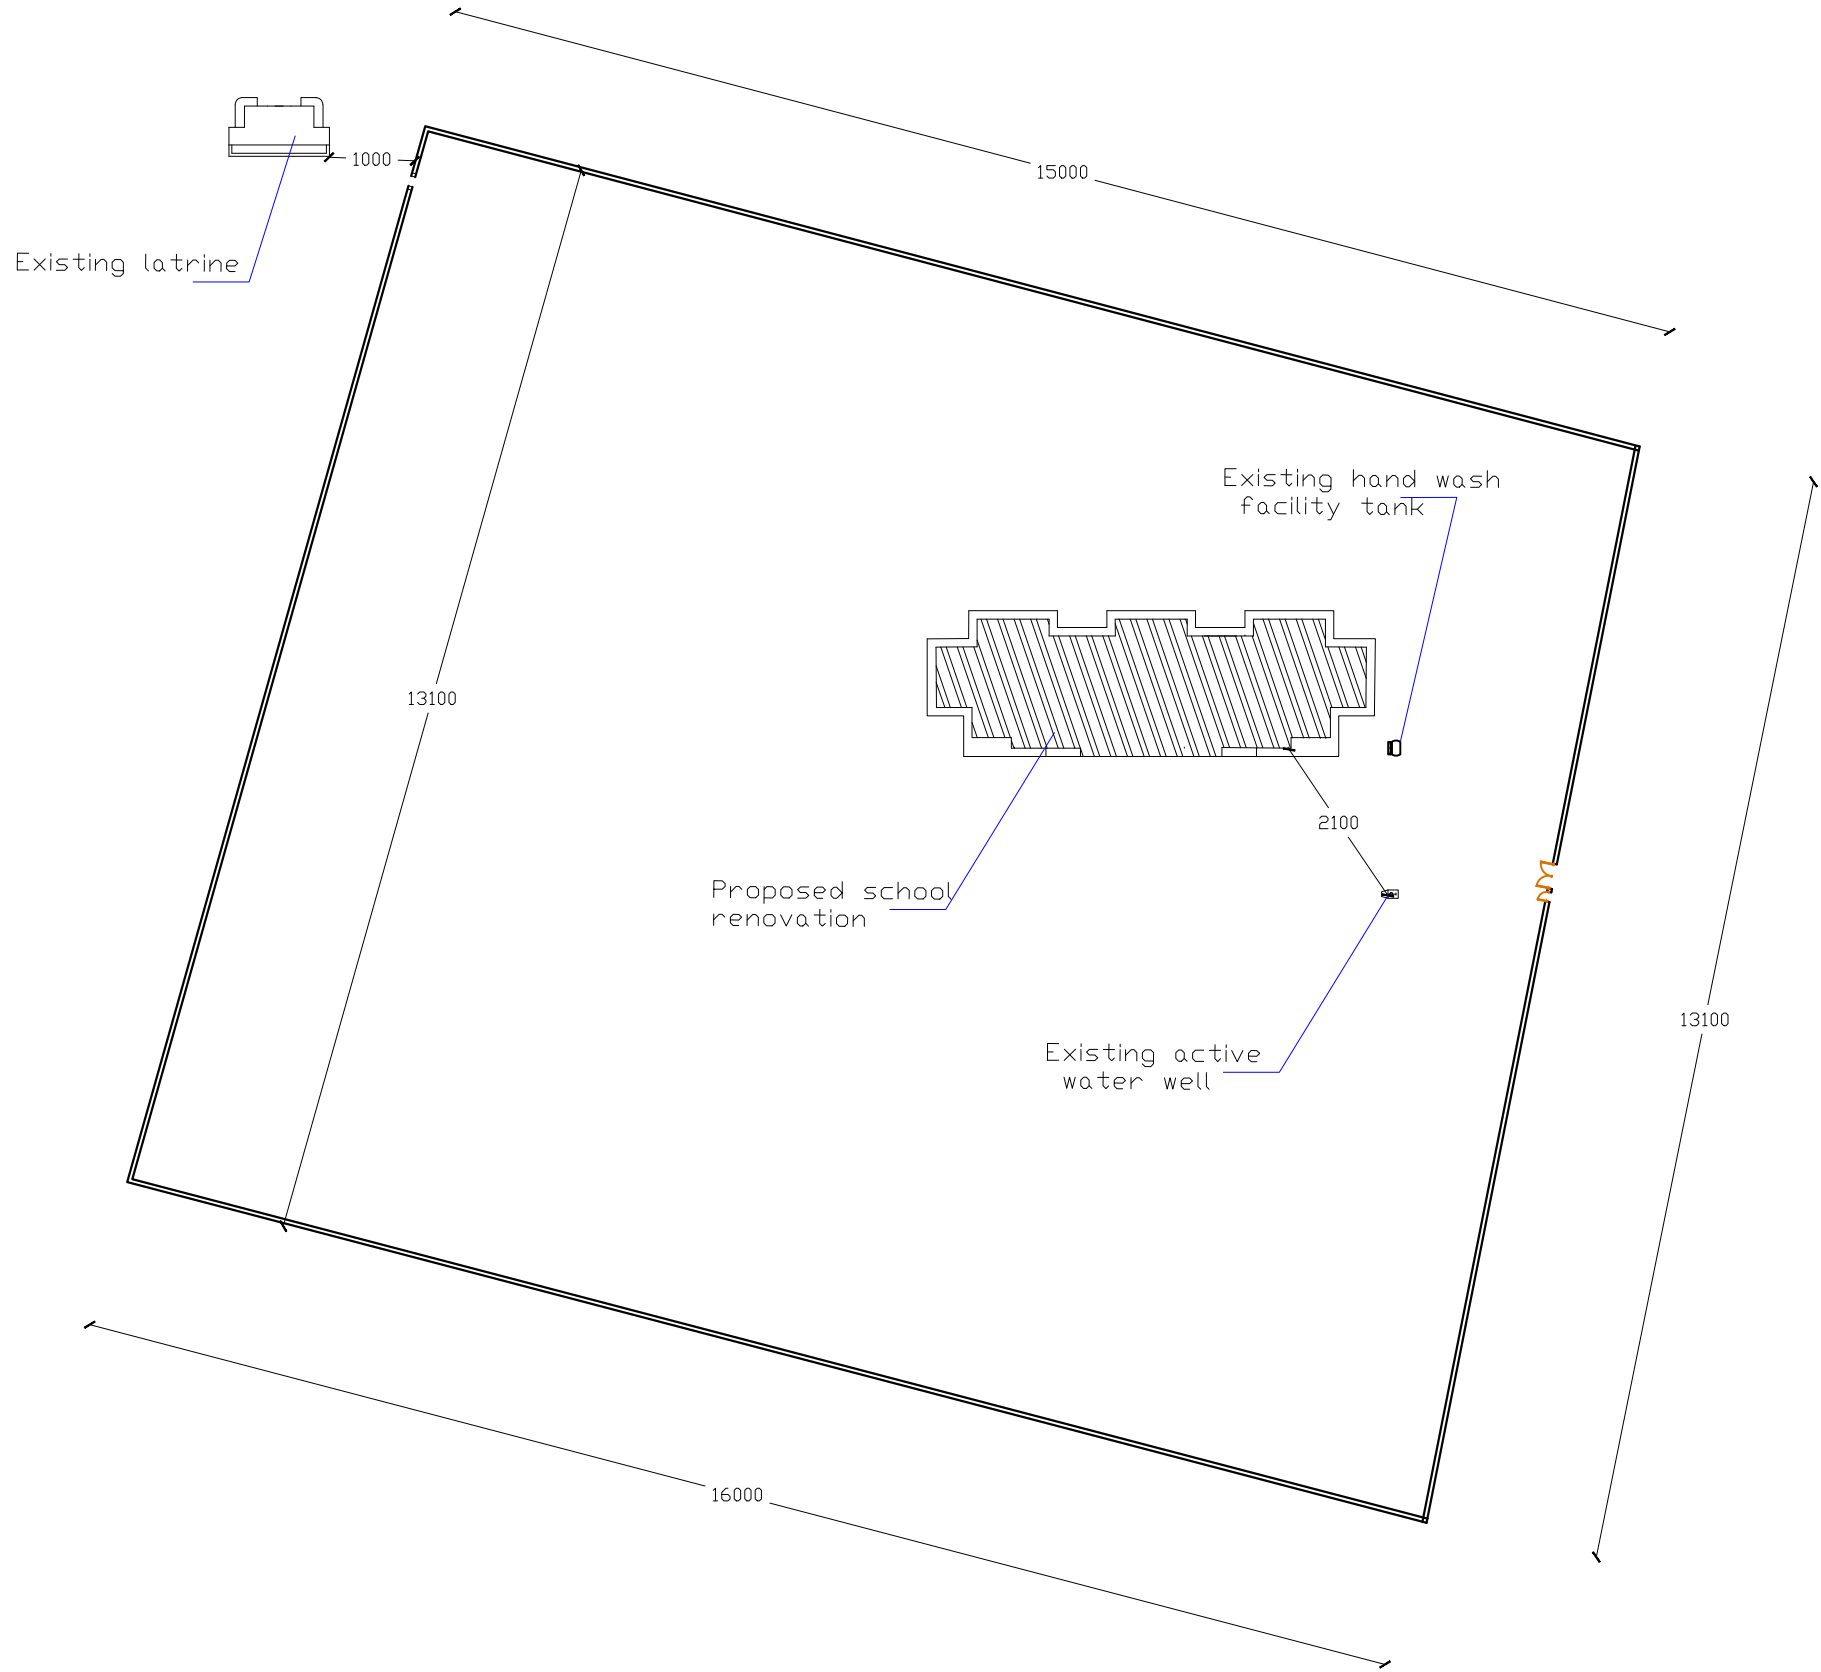

Site Plan of the project




Door Window	#	Sizes
D1	10	100 x255 cm
D2	2	80 x180 cm
Dw1	1	790 x255 cm
Dw2	2	375 x255cm
W1	32	100 x190 cm
W2	16	100 x70 cm
W3	4	150x190 cm
W4	7	70x400 cm
H		280cm







Door Window	#	Sizes
D1	10	100 x255 cm
D3	1	200 x255 cm
Dw2	2	375 x255cm
W1	32	100 x190 cm
W2	18	100 x70 cm
W5	2	380x190 cm
W6	7	70x190 cm
H		280cm

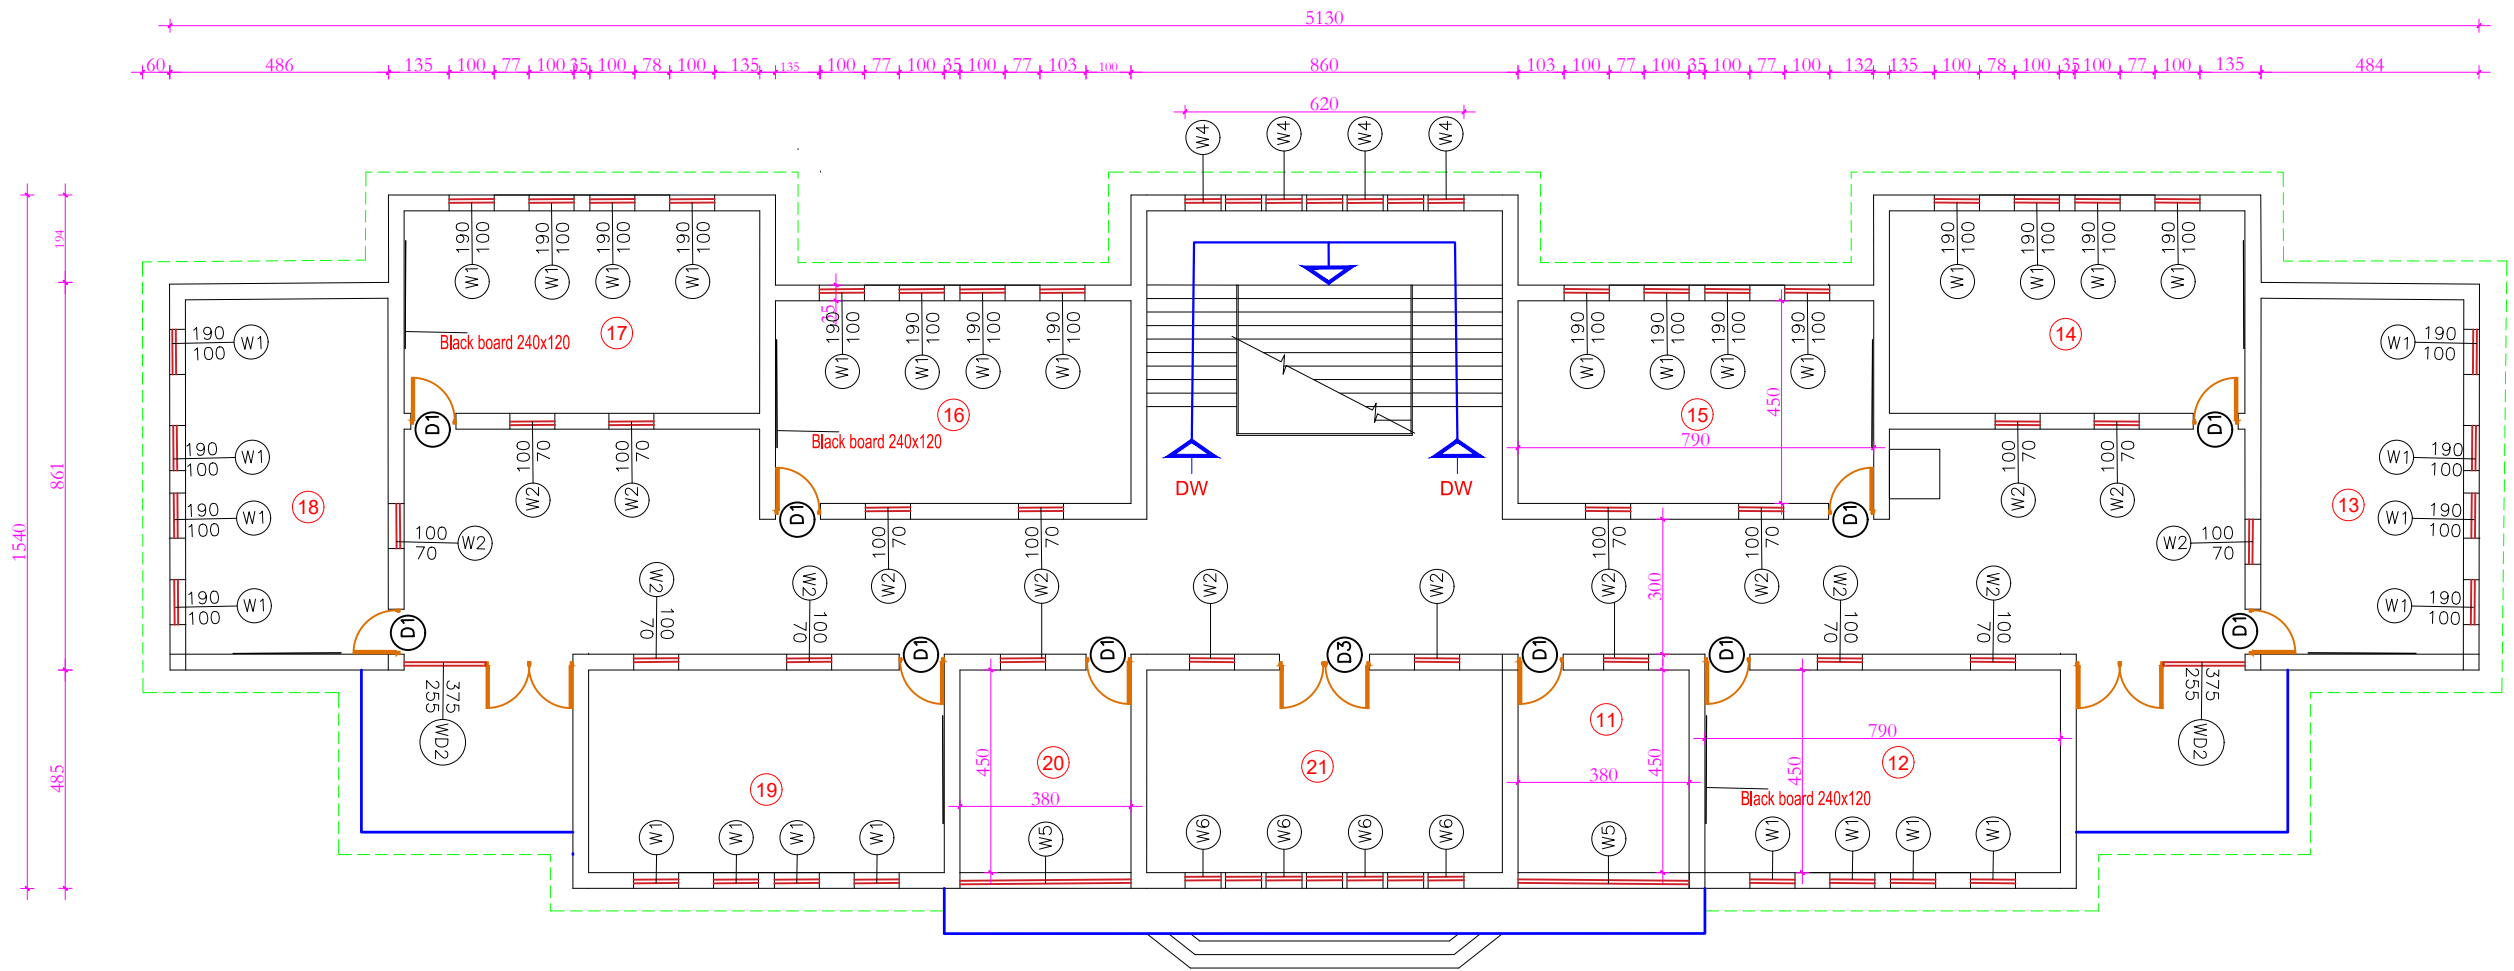






 

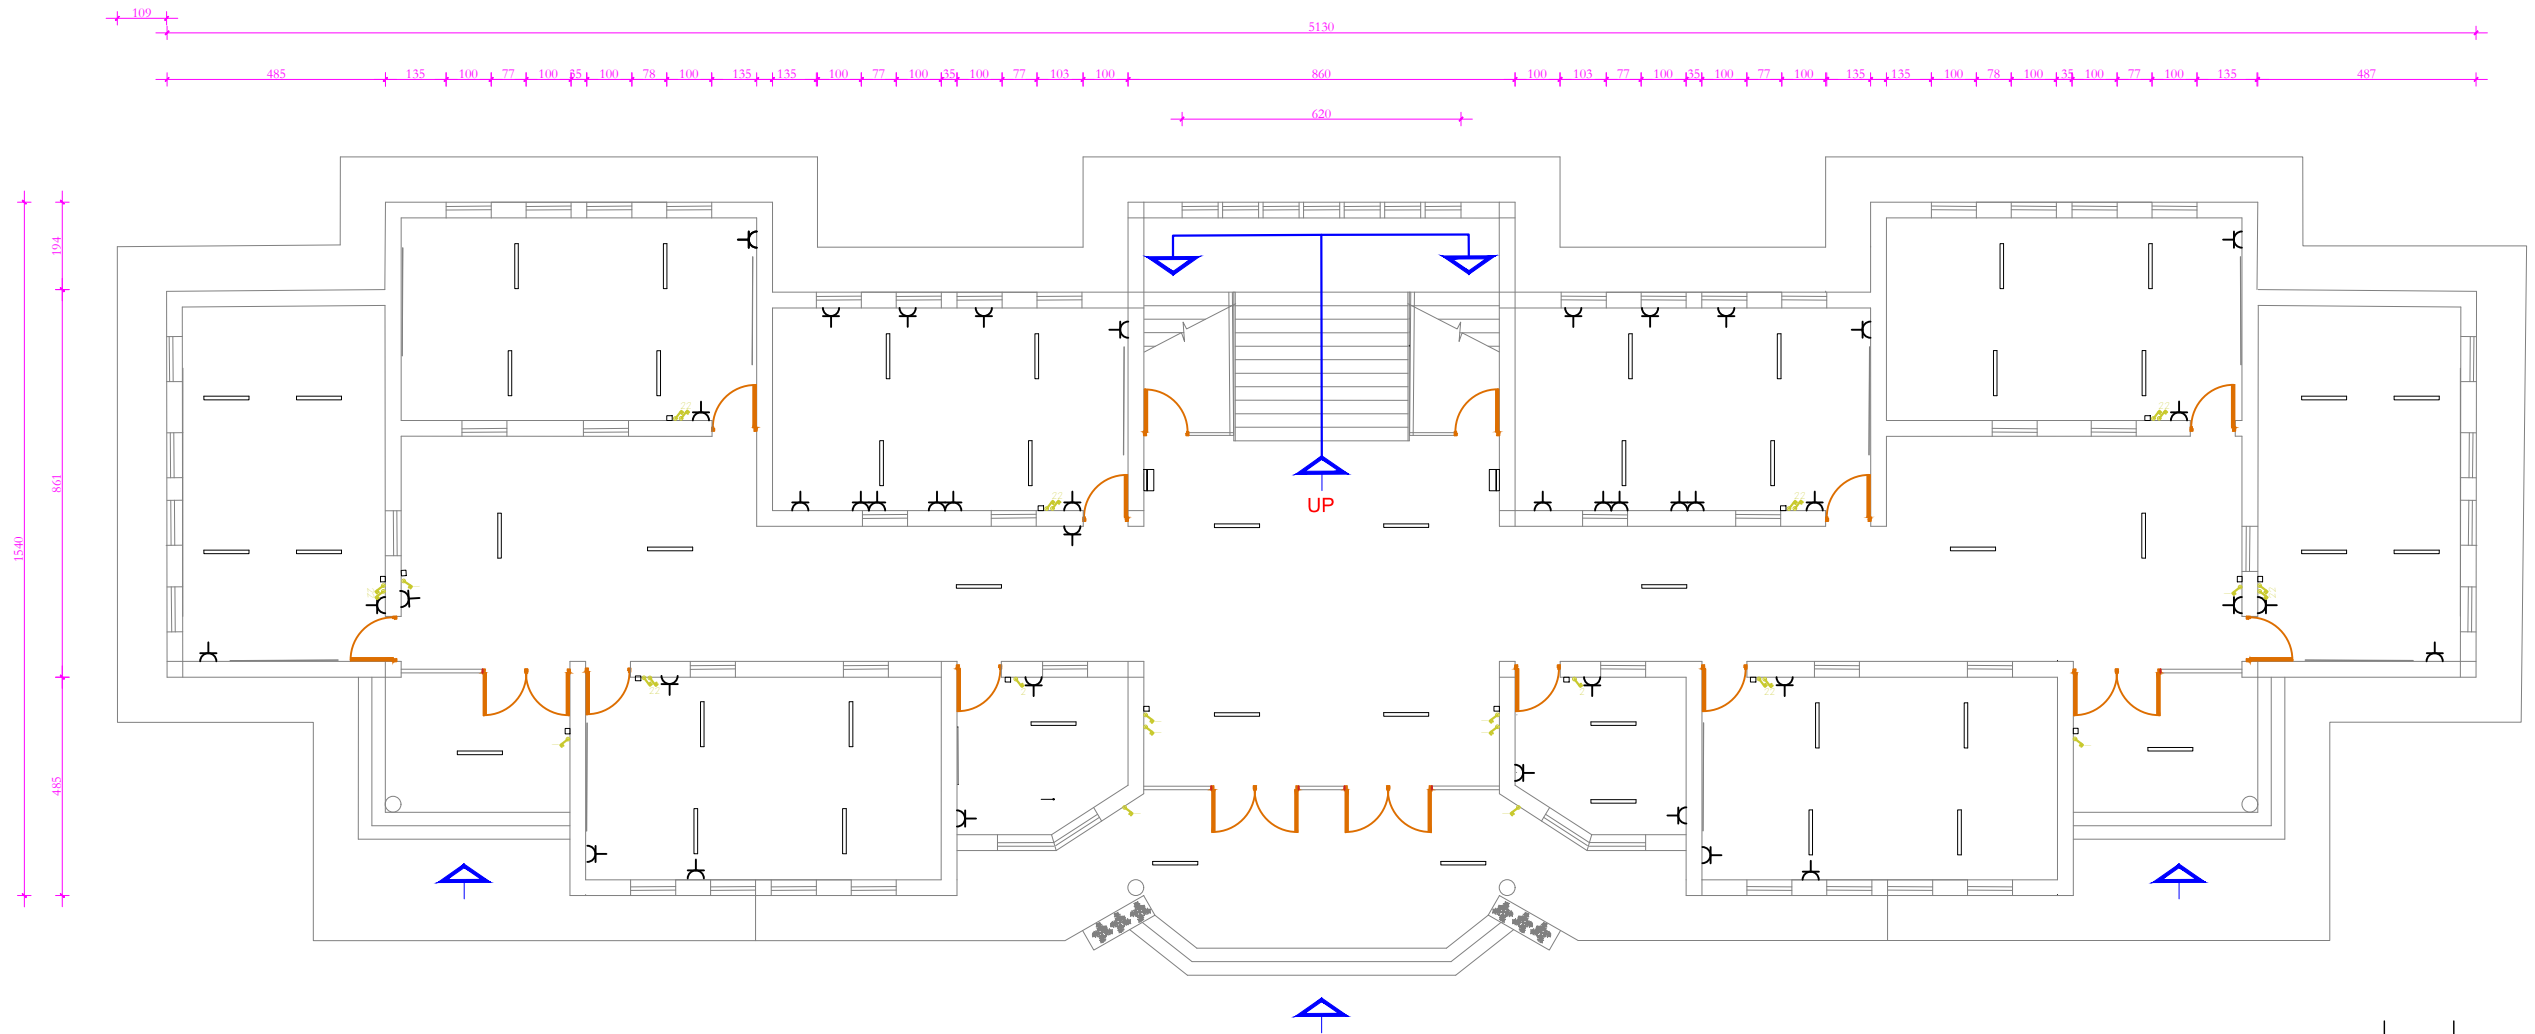



# Existence school Second Floor plan

 


UNICEF		C.S	SHEET No	A-9/10
			SCALE	AS SHOWN
DATE				ADDN 2024




# Existence school First Floor Electrical plan

NO.	DESCRIPTION	SIGNS	UNIT	PIECES	REMARKS
1	CEILING NEON LAMP 180w		NO	88	NEED ON NEON LAMP OF ROOM #10
2	SOCKET OUTLET - SINGLE PHASE		NO	84	
3	SWITCHES UNDER PLASTER ONE POLE		NO	20	
4	DOUBLE/TWO POLE SWITCHES UNDER PLASTER		NO	40	
5	WIRE 1/2x1.5mm TYPE NYF		M	0	
6	WIRE 1/2x2.5mm TYPE NYF		M	0	
7	CABLE 12x6mm FOR Connection of building TYPE NYF <sup>2</sup>		M	0	
8	FUSE BOX FOR 4 FUSE		NO	4	
9	Joint Box		NO	28	
10	FUSE 10A		NO	0	
11	FUSE 20A		NO	0	

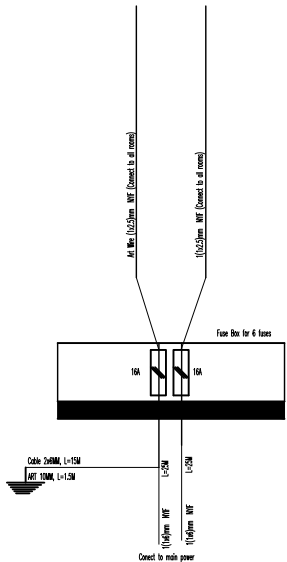





PROJECT EMPLOYER

UNITED NATIONS CHILDREN'S FUND

construction section

Renovation of Toriyab Boys and girls High School


All dimension are in cm

TITLE :LATRINE EXISTENCE PLAN

DRAWING BYMOHAMMAD HAMAYOON "KARIM"

CHECKED BY

APPROVED BY

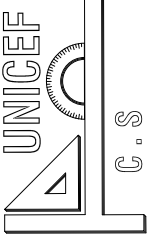

C.S

SHEET NoA-10/10

SCALEAS SHOWN

DATEFEB. 2024

The diagram shows a U-shaped building layout for a latrine. The building has 10 stalls, each with a toilet and a window. There are 8 D1 doors (70 x 230 cm) and 2 D2 doors (90 x 230 cm). The building is surrounded by a wall with 12 windows (50 x 50 cm). The dimensions are provided in cm: 35, 150, 90, 15, 90, 15, 90, 15, 90, 25, 90, 15, 90, 15, 90, 25, 90, 150, 35. The total width is 150 cm and the total length is 25 cm.

Existing latrine Plan

Door Window	#	Sizes
D1	8	70 x230 cm
D2	2	90 x230 cm
W1	12	50 x50 cm
W2	2	80 x50 cm
W3	6	150 x50 cm
H		250 cm