


# Gawhargin School

## Legend of Site Plan

A	Planned Building
B	Planned Latrines 5
C	Planned Water well, Dept (120)m
D	Hand washing station(1)

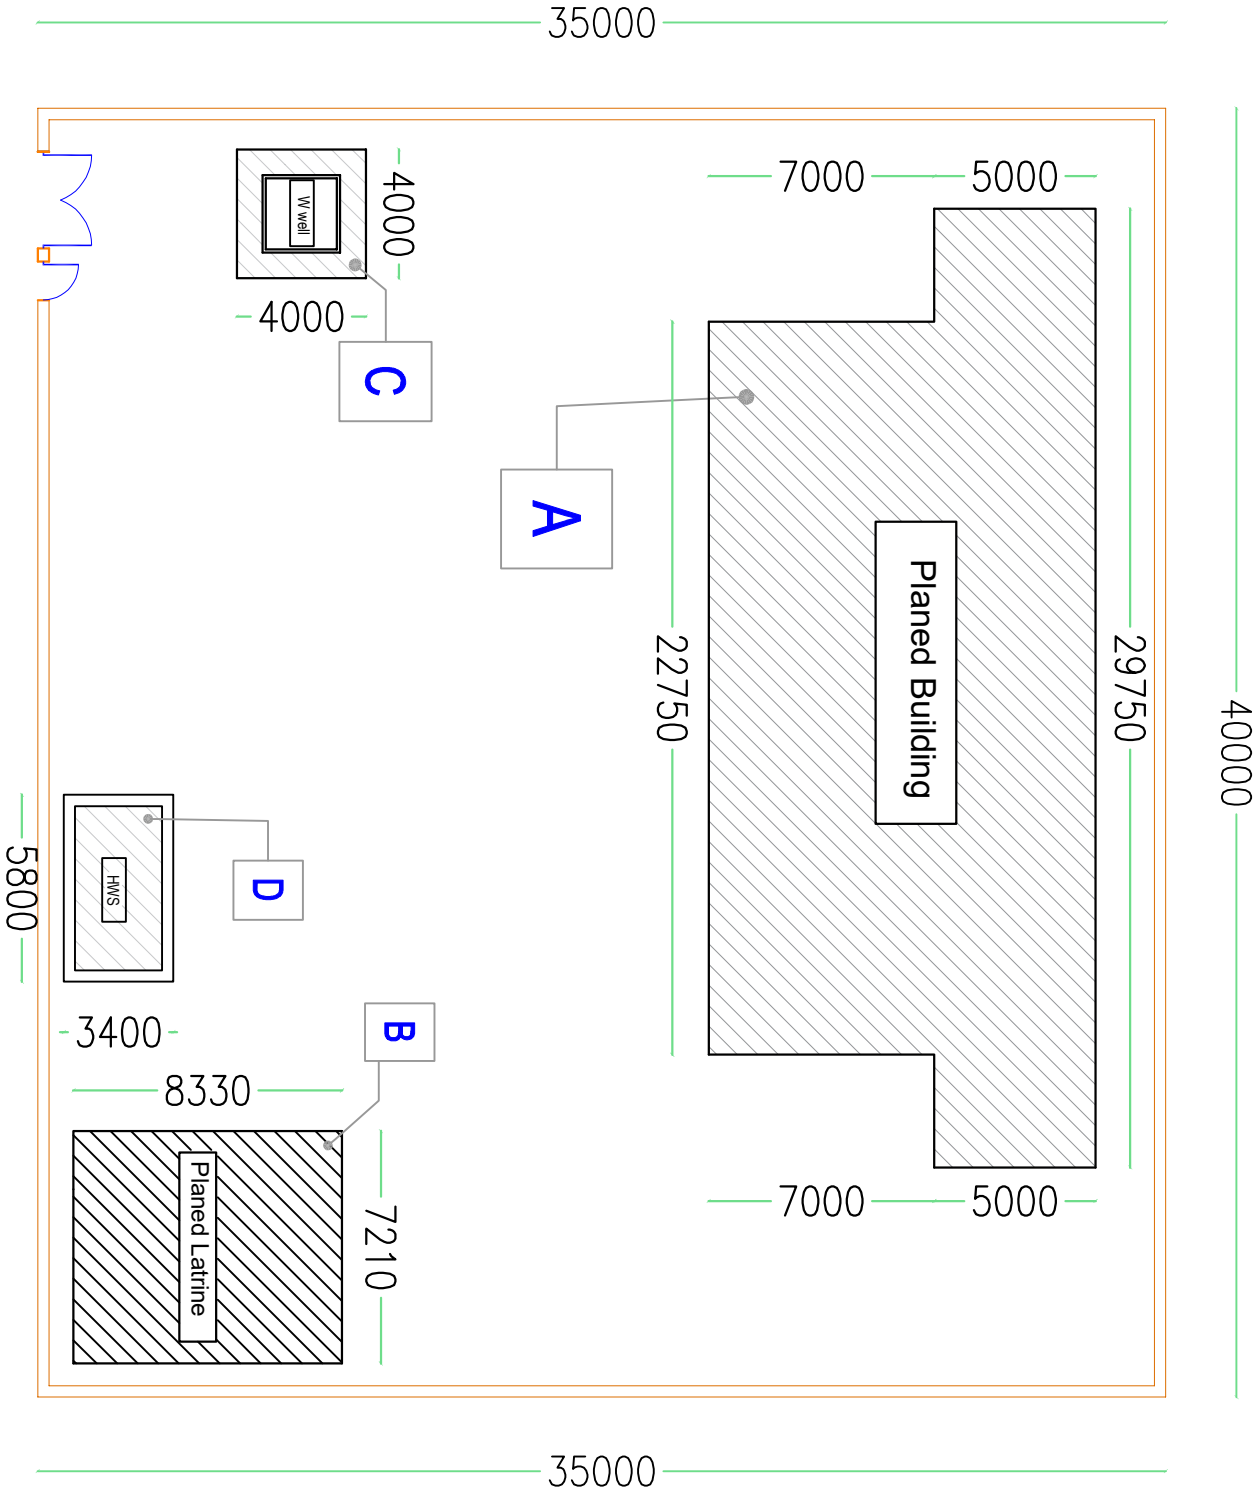

### 01 Site Plan of Gawhargin School

N/S

Note:

- 1.All dimensions are in mm unless otherwise specified
- 2.The planed activities will be constructed based on the site condition



Ministry of Education Infrastructure service  
Department (I.S.D)

Designed by:	
Drawn by:	Eng M.Hashim Hamdard
Checked By	Eng Nazifullah Akrami
WASH Focal point :	
Approved by	
Visa Committee:	

No.	Submission	Date:
(01)	For Tender(If drawn from primary data)	10/07/2023

Contract No:	
Contract Date:	
Fiscal Year:	
Drawn Code:	A3
Pilot Date:	
Scale:	

ISD ( Ministry of Education Infrastructure Service Department)  
Gawhargin School  
Uruzgan , Afghanistan

School Code  
(260600015)